

SHEET: **P001**

PERMIT SET




GENERAL NOTES

1. UNLESS OTHERWISE NOTED, SANITARY PIPING SHOWN IS BELOW SLAB.
2. UNLESS OTHERWISE NOTED, VENT & STORM PIPING IS SHOWN ABOVE SLAB.



LS3P


101 NORTH THIRD STREET, SUITE 500
WILMINGTON, NORTH CAROLINA 28401
TEL. 910.790.9901 FAX. 910.790.3111
WWW.LS3P.COM

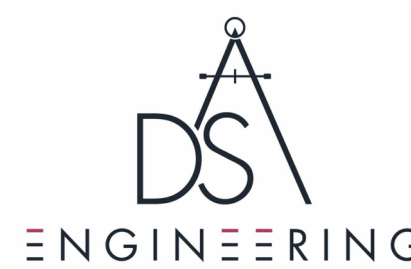

NC LICENSE: C-1150

101 N. 3RD ST.
STE. 403
WILMINGTON, NC 28401

910.791.8016
DSAENG.COM

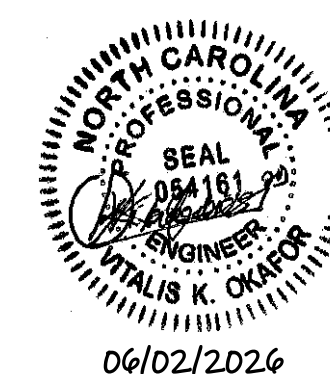

COPYRIGHT 2024 ALL RIGHTS RESERVED. PRINTED &
ELECTRONIC DRAWINGS AND DOCUMENTATION MAY
NOT BE REPRODUCED IN ANY FORM WITHOUT WRITTEN
PERMISSION FROM LS3P ASSOCIATES LTD.

FLAGSHIP MEDICAL PLAZA

MOB II

3601 CONVERSE ROAD
WILMINGTON, NC 28403

OSHA PROJECT: 25017

[illegible]

SHEET NAME:
PLUMBING D.W.V.
PIPING PLAN -
LEVEL 2

ORIG 2026.05.29
SUBMISSION:


SHEET:

P102

PERMIT SET



1	PLUMBING SANITARY & VENT LEVEL 2
E402	SCALE: 1/8" = 1'-0"

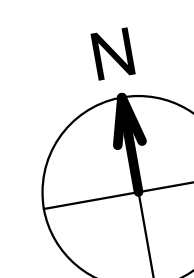

GRAPHIC SCALE



8 4 0 8

SCALE: 1/8" = 1'-0"

UNIT OF MEASURE: FEET

**FLAGSHIP MEDICAL PLAZA
MOB II**

WILMINGTON, NC 28403

DSA PROJECT: 25017



[illegible]

SHEET NAME:
PLUMBING D.W.V.
PIPING PLAN -
ROOF

ORIG 2026.05.29
SUBMISSION:

SHEET: **P103**

ERMIT SET

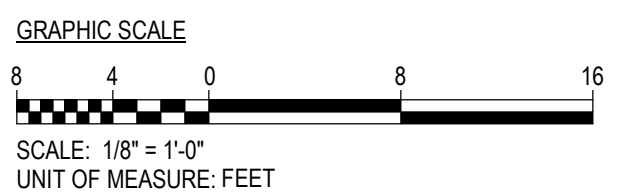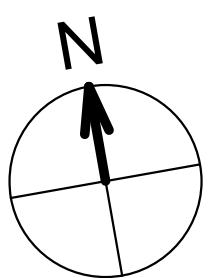

3001 CONVERSE ROAD
WILMINGTON, NC 28403

DSA PROJECT: 25017

[illegible]

HEET NAME:
PLUMBING
DOMESTIC PIPING
PLAN - LEVEL 1


IG 2026.05.29
MISSION:

EET: **P201**


PERMIT SET

- 1 2" CW WITH SHUTOFF VALVE CAPPED IN CEILING SPACE FOR FUTURE UPFITS.
- 2 2" CW WITH SHUTOFF VALVE ROUTES UP TO SECOND LEVEL.
- 3 SEE ARCHITECTURAL DRAWINGS FOR EXTERIOR HOSEBIB INSTALLATION DETAIL TO DETERMINE EXACT LOCATION IN WALL PANEL.
- 4 BACKFLOW PREVENTER PROVIDED BY CIVIL. SEE CIVIL DRAWINGS FOR CONTINUATION.

	NON-RATED PARTITION TO 6" ABOVE CEILING, UNO
	NON-RATED PARTITION TO DECK
	NON-RATED SMOKE PARTITION TO DECK
	RATED SMOKE BARRIER TO DECK
	RATED FIRE PARTITION TO DECK
	RATED FIRE/SMOKE BARRIER TO DECK
	RATED FIRE BARRIER TO DECK
	RATED FIRE WALL TO DECK

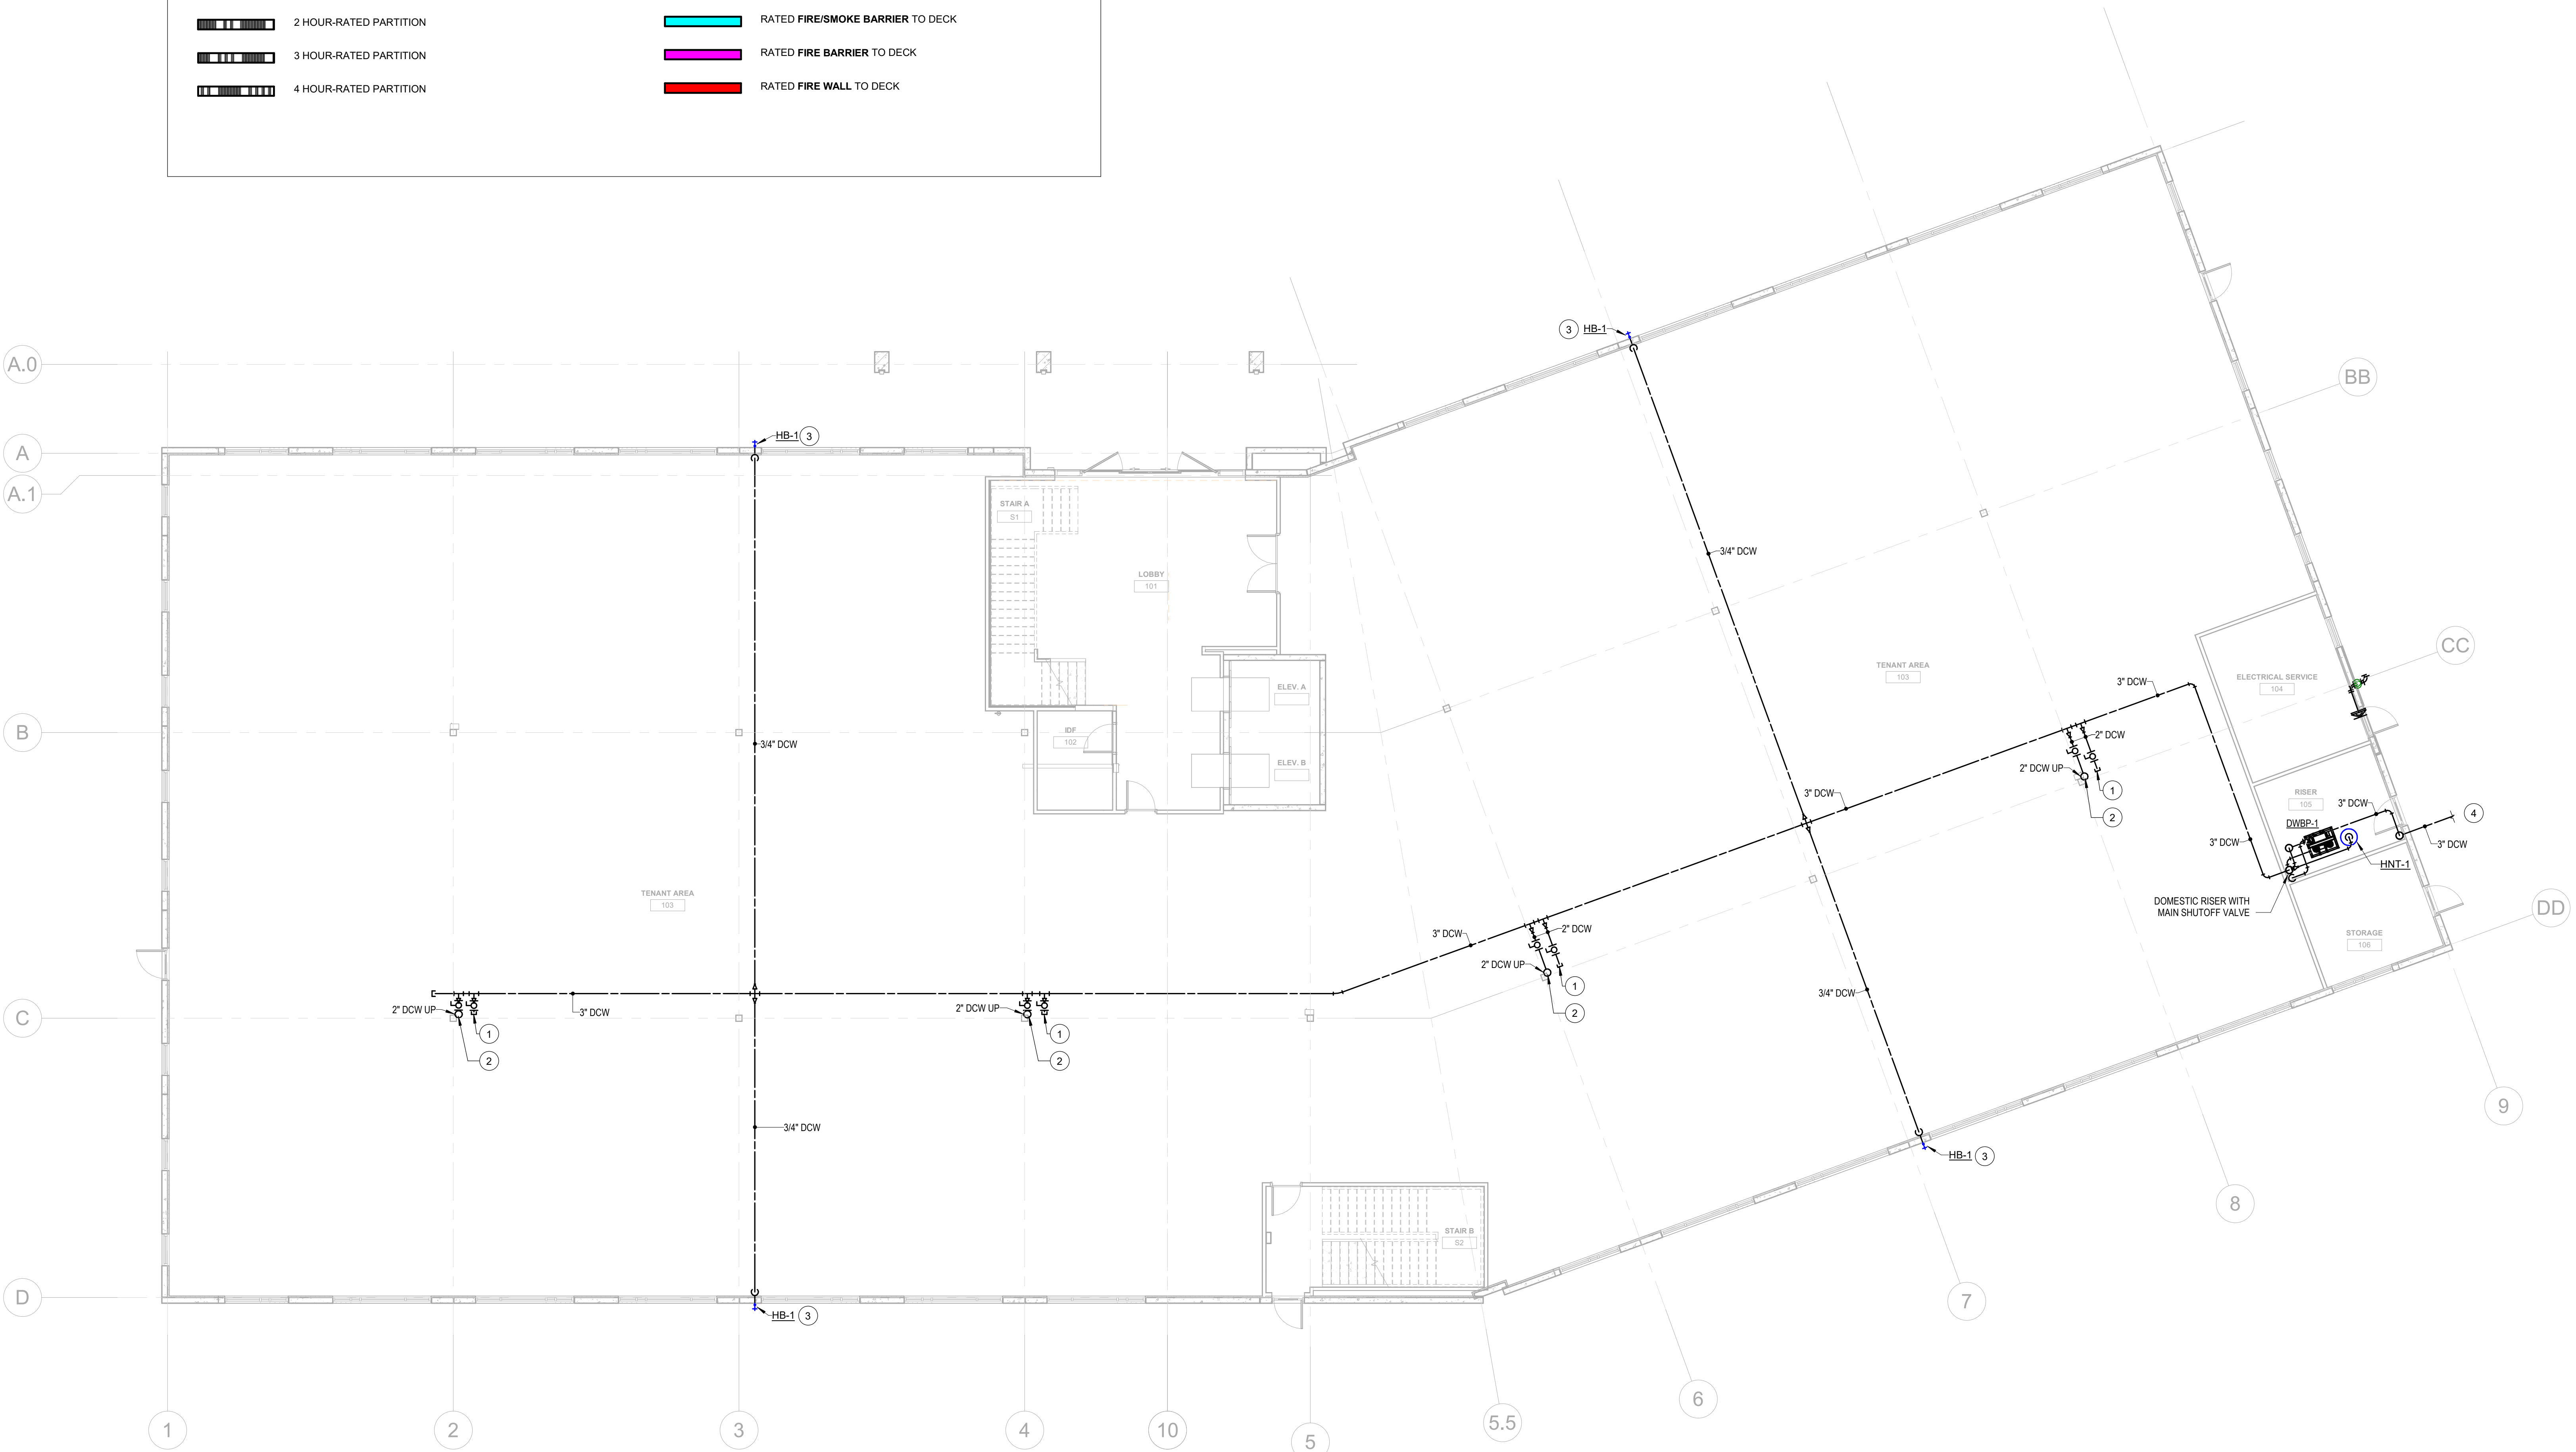

1	PLUMBING DOMESTIC LEVEL 1
	SCALE: 1/8" = 1'-0"

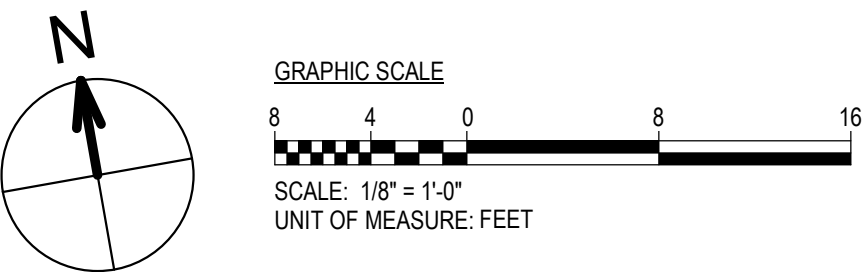




- ① 2" CW WITH SHUTOFF VALVE CAPPED IN CEILING SPACE FOR FUTURE UPFITS.
- ② 2" CW FROM FIRST FLOOR.




LS3P

101 NORTH THIRD STREET, SUITE 500
WILMINGTON, NORTH CAROLINA 28401
TEL. 910.790.9901 FAX. 910.790.3111
WWW.LS3P.COM

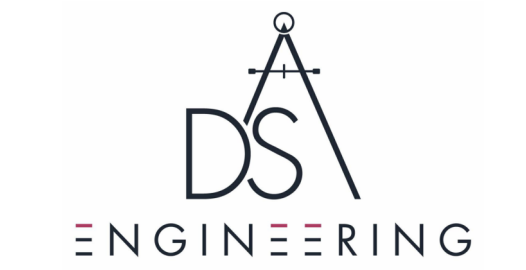

NC LICENSE: C-1150
101 N. 3RD ST.
STE. 403 910.791.8016
WILMINGTON, NC 28401 DSAENG.COM

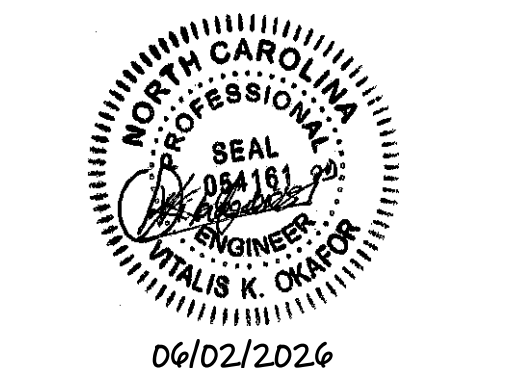

COPYRIGHT 2024 ALL RIGHTS RESERVED. PRINTED OR
ELECTRONIC DRAWINGS AND DOCUMENTATION MAY
NOT BE REPRODUCED IN ANY FORM WITHOUT WRITTEN
PERMISSION FROM LS3P ASSOCIATES LTD.

FLAGSHIP MEDICAL PLAZA

MOB II
33601 CONVERSE ROAD
WILMINGTON, NC 28403

DSA PROJECT: 25017

[illegible]

SHEET NAME:
PLUMBING
DOMESTIC PIPING
PLAN - LEVEL 2

ORIG 2026.05.29
SUBMISSION:

SHEET: **P202**

PERMIT SET

THE LINE SHOWN ABOVE IS EXACTLY
ONE FOOT IN LENGTH
FOR GRAPHIC SCALE

E


D

C


B

A

6/22/2026 5:59:40 PM

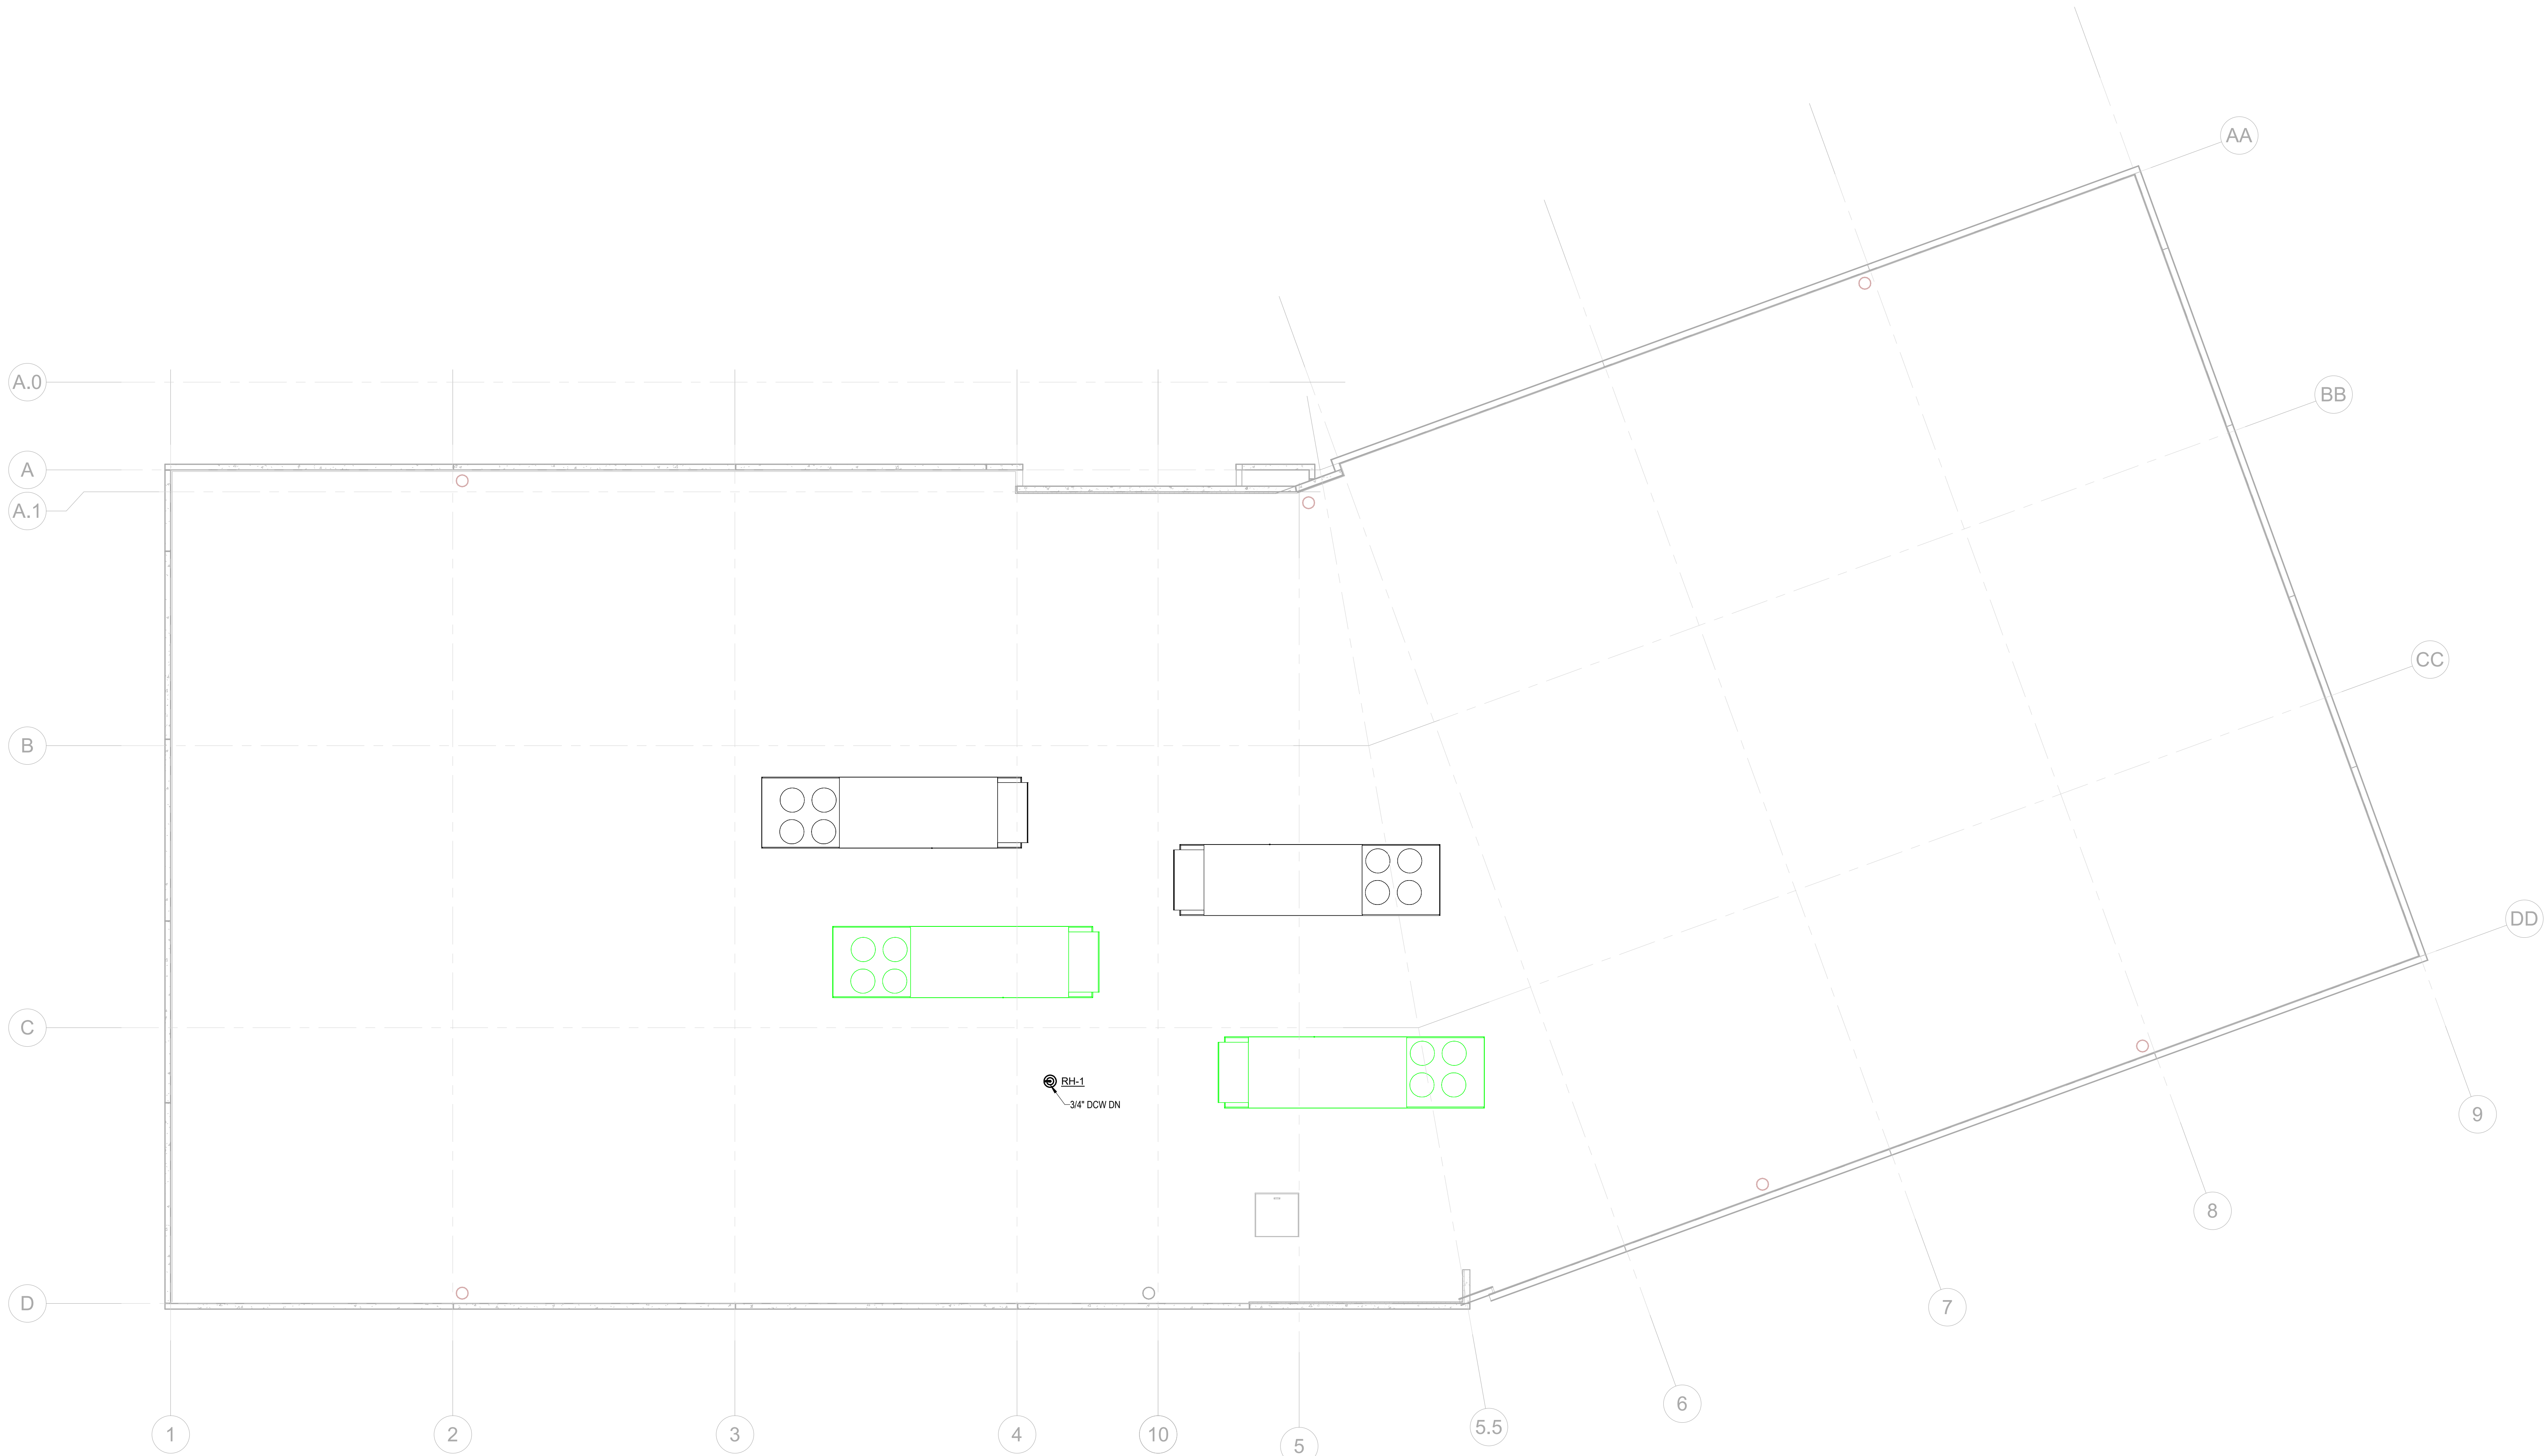

1 PLUMBING DOMESTIC ROOF
E402 SCALE: 1/8" = 1'-0"

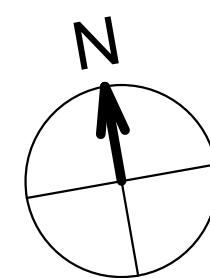


GRAPHIC SCALE
8 4 0 8 16
SCALE: 1/8" = 1'-0"
UNIT OF MEASURE: FEET



101 NORTH THIRD STREET, SUITE 500
WILMINGTON, NORTH CAROLINA 28401
TEL. 910.790.9901 FAX. 910.790.3111
WWW.LS3P.COM



NC LICENSE: C-1150
101 N. 3RD ST.
STE. 403 910.791.8016
WILMINGTON, NC 28401 DSAENG.COM

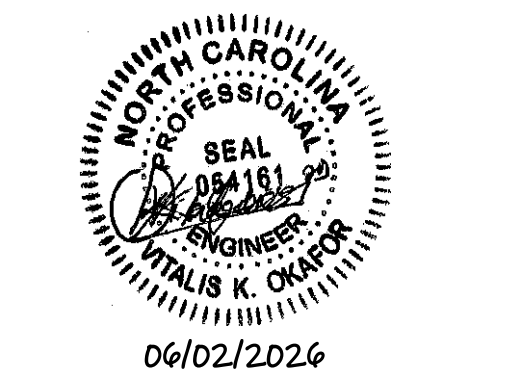

COPYRIGHT 2024 ALL RIGHTS RESERVED. PRINTED OR
ELECTRONIC DRAWINGS AND DOCUMENTATION MAY
NOT BE REPRODUCED IN ANY FORM WITHOUT WRITTEN
PERMISSION FROM LS3P ASSOCIATES LTD.

**FLAGSHIP MEDICAL PLAZA
MOB II**
3601 CONVERSE ROAD
WILMINGTON, NC 28403
DSA PROJECT: 25017

Δ	DATE	DESCRIPTION
A	2026.05.29	PERMIT SET

SHEET NAME:
PLUMBING
DOMESTIC PIPING
PLAN - ROOF

ORIG SUBMISSION: 2026.05.29

SHEET:
P203

PERMIT SET

FLAGSHIP MEDICAL PLAZA

MOB II
3601 CONVERSE ROAD
WILMINGTON, NC 28403

DSA PROJECT: 25017


[illegible]

SHEET NAME:
PLUMBING D.W.V.
PIPING PLAN -
ISOMETRIC

ORIG 2026.05.29
SUBMISSION:

SHEET: **P401**

ERMIT SET

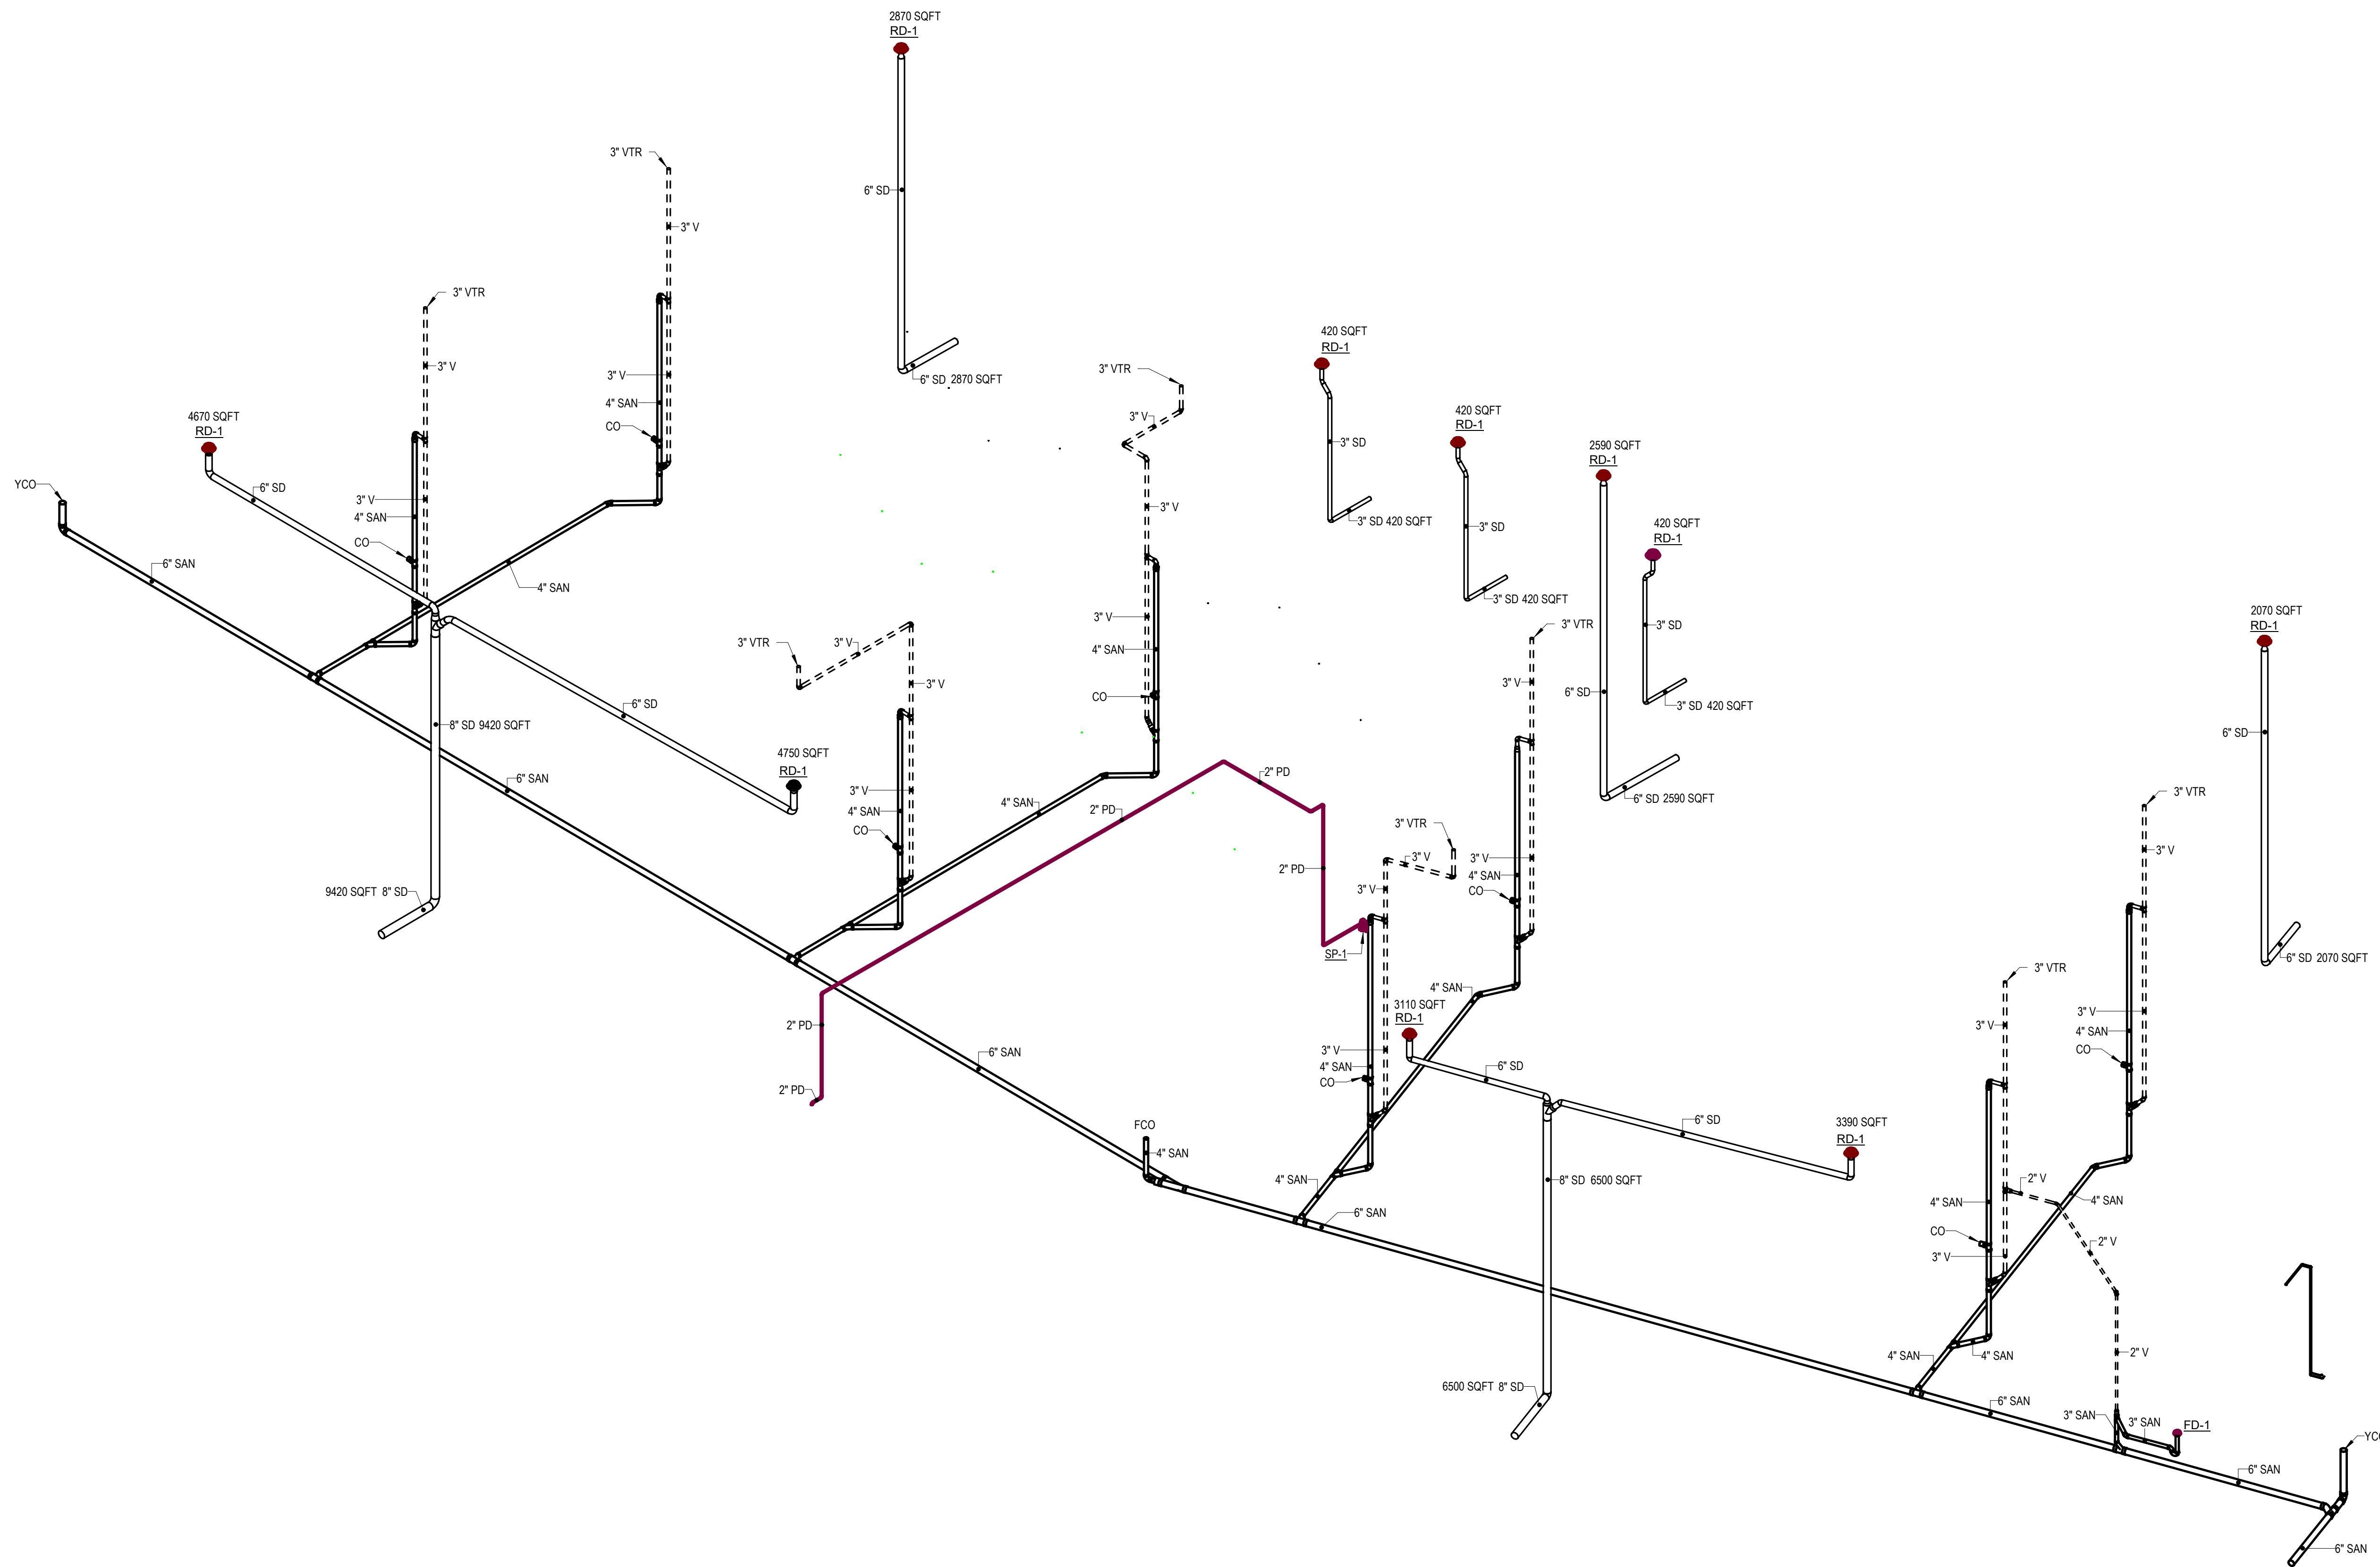

1	D.W.V. ISOMETRIC
	SCALE: N.T.S.

THE LINE SHOWN ABOVE IS EXACTLY
ONE INCH LONG AT THIS SHEETS
ORIGINAL PAGE SIZE

E

D

C

B

A

6/2/2026 5:59:41 PM

1

2

3

4

5

6

THE LINE SHOWN ABOVE IS EXACTLY
ONE FOOT AND ONE EIGHTH INCH
LONG AND ONE EIGHTH INCH
WIDE

E

D

C

B

A

6/22/2026 5:59:42 PM

1


2

3

4

5

6

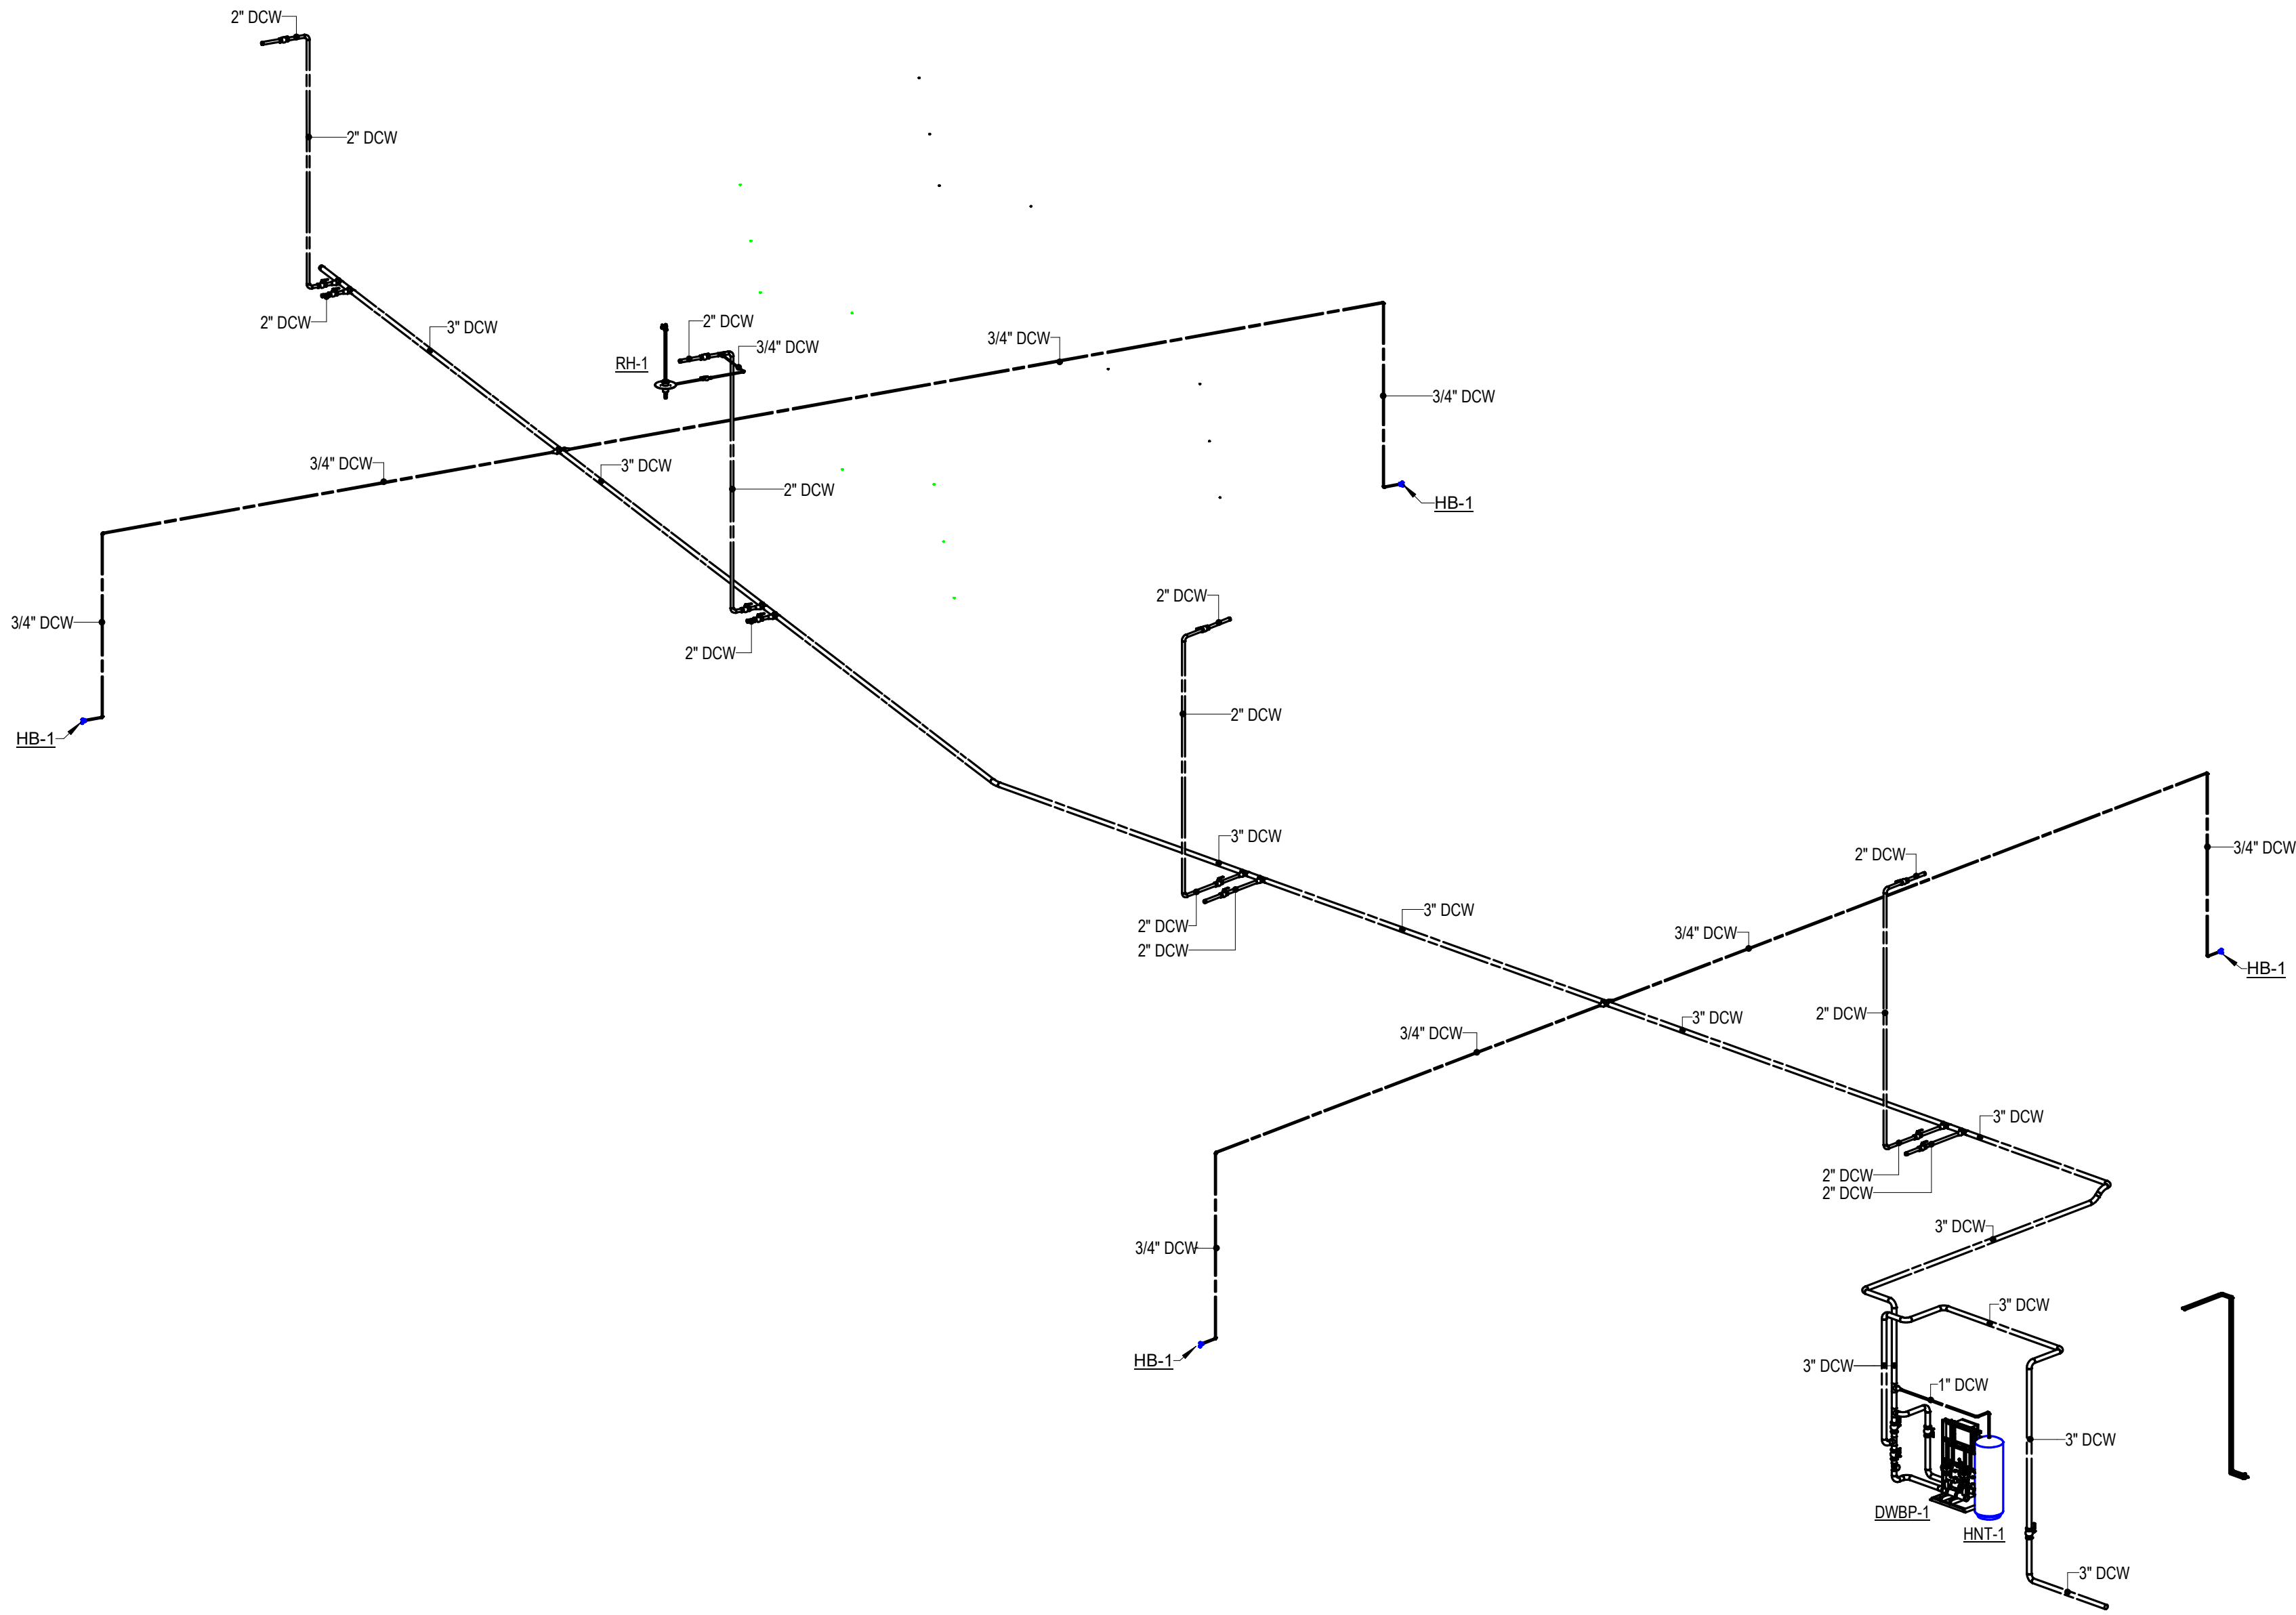


1 PLUMBING DOMESTIC - ISOMETRIC
SCALE: N.T.S.



101 NORTH THIRD STREET, SUITE 500
WILMINGTON, NORTH CAROLINA 28401
TEL. 910.790.9901 FAX. 910.790.3111
WWW.LS3P.COM



NC LICENSE: C-1150
101 N. 3RD ST. 910.791.8016
STE. 403 WILMINGTON, NC 28401 DSAENG.COM

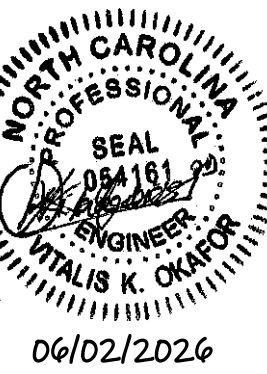

COPYRIGHT 2024 ALL RIGHTS RESERVED. PRINTED OR
ELECTRONIC DRAWINGS AND DOCUMENTATION MAY
NOT BE REPRODUCED IN ANY FORM WITHOUT WRITTEN
PERMISSION FROM LS3P ASSOCIATES LTD.

**FLAGSHIP MEDICAL PLAZA
MOB II**
3601 CONVERSE ROAD
WILMINGTON, NC 28403
DSA PROJECT: 25017

Δ	DATE	DESCRIPTION
A	2026.05.29	PERMIT SET

SHEET NAME:
PLUMBING
DOMESTIC PIPING
PLAN - ISOMETRIC

ORIG 2026.05.29
SUBMISSION:

SHEET:
P402

PERMIT SET

A

1	ELEVATOR SUMP PUMP
	SCALE: N.T.S.

2	PIPE CLAMP SUPPORT
	SCALE: N.T.S.

NOTE:

1. UNIT IS FACTORY ASSEMBLED. PROVISIONS MUST BE MADE TO PROPERLY SECURE PACKAGE TO HOUSEKEEPING PAD AND PER MANUFACTURER'S RECOMMENDATIONS.

3	BOOSTER PUMP
	SCALE: N.T.S.

4 | **SANITARY VENT THROUGH ROOF**
SCALE: N.T.S.

5	FINISHED FLOOR CLEANOUT PLASTIC PIPE
	SCALE: N.T.S.

6	FLOOR DRAIN
	SCALE: N.T.S.

7	INSULATED PIPE OR TUBING ISOLATION SUPPORT
	SCALE: N.T.S.

[illegible]

SHEET NAME:
PLUMBING DETAILS

ORIG 2026.05.29
SUBMISSION:

SHEET: **P501**

PERMIT SET

DSA PROJECT: 25017

NOTES:
1. SEE FLOOR PLANS FOR DRAIN SIZES AND REQUIRED ACCESSORIES.

[illegible]

SHEET:

P701