 


10/15/2025 12:15:21 PM



- A. ANY PIPE INVERT ELEVATIONS PROVIDED ON THE PLANS ARE FOR REFERENCE ONLY.
- B. REFER TO PLUMBING FIXTURE SCHEDULE FOR FIXTURE DOMESTIC WATER, SANITARY AND VENT PIPING CONNECTION SIZES.
- C. PROVIDE TRAP PRIMER CONNECTION TO ALL FLOOR DRAINS.
- D. REFER TO FOOD SERVICE PLANS FOR ADDITIONAL INFORMATION ON REQUIRED SANITARY CONNECTIONS TO FOOD SERVICE EQUIPMENT.

1. 6" STORMY TO MAIN, INV. ELEV. 4'-6" COORDINATE WITH CIVIL SITE PLAN PRIOR TO INSTALLATION.
2. 4" STORMY TO MAIN, INV. ELEV. 3'-0" COORDINATE WITH CIVIL SITE PLAN PRIOR TO INSTALLATION.
3. 18" POOL BACKWASH DISCHARGE FROM SUMP PIT, COORDINATE WITH POOL EQUIPMENT VENDOR AND CIVIL SITE PLAN PRIOR TO INSTALLATION.
4. 6" MAIN AND OVERFLOW DRAIN PIPING UP TO ROOF DRAIN, TYPICAL.
5. 6" MAIN ROOF DRAIN PIPING ROUTED UNDERGROUND TO STORM DRAIN SYSTEM COORDINATE WITH CIVIL SITE PLANS PRIOR TO INSTALLATION, TYPICAL.
6. OVERFLOW ROOF DRAIN PIPING SHALL DISCHARGE THROUGH WALL ABOVE GRADE, TYPICAL.
7. FINAL STORM AND OVERFLOW DRAIN RISER LOCATIONS SHALL BE COORDINATED WITH THE ARCHITECT IN THE FIELD, TYPICAL.



9930 Ocean Isle Beach Road SW
Shallotte, NC 28470


US3P PROJECT: 7154-231756

[illegible]

ORIG 2025.10.15
SUBMISSION:

P101

PERMIT SET

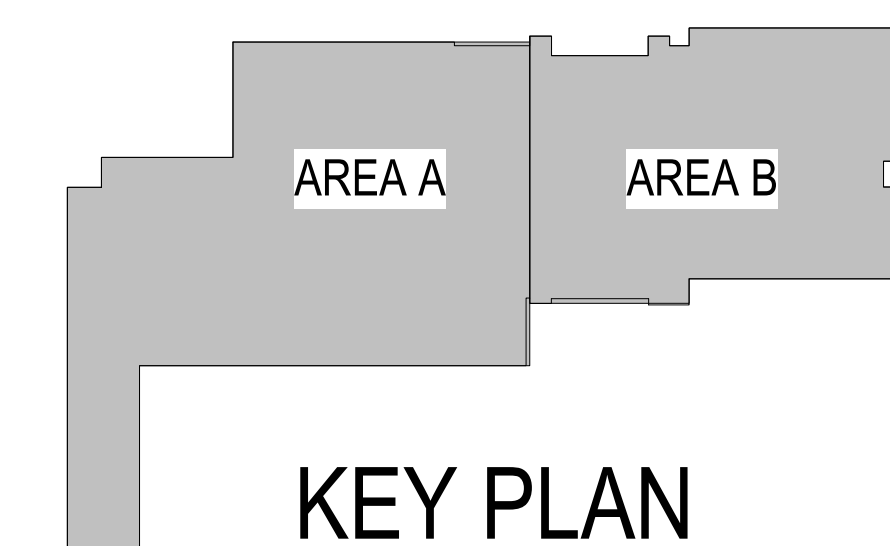

10/15/2025 12:15:27 PM


A. ANY PIPE INVERT ELEVATIONS PROVIDED ON THE PLANS ARE FOR REFERENCE ONLY.

B. REFER TO PLUMBING FIXTURE SCHEDULE FOR FIXTURE DOMESTIC WATER, SANITARY AND VENT PIPING CONNECTION SIZES.



LS3P

101 NORTH THIRD STREET, SUITE 500
WILMINGTON, NORTH CAROLINA 28401
TEL. 910.790.9901 FAX. 910.790.3111
WWW.LS3P.COM

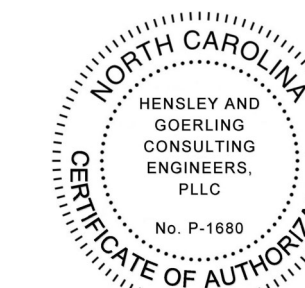

COPYRIGHT 2024 ALL RIGHTS RESERVED. PRINTED OR
ELECTRONIC DRAWINGS AND DOCUMENTATION MAY
NOT BE REPRODUCED IN ANY FORM WITHOUT WRITTEN
PERMISSION FROM LS3P ASSOCIATES LTD.

**Pulte Del Webb Ocean Isle
Beach Amenity Center**

930 Ocean Isle Beach Road SW
Shallotte NC 28470

S3P PROJECT: 7154-231756


[illegible]

SHEET NAME:
PLUMBING -
SANITARY AND
VENT - ROOF PLAN

ORIG 2025.10.15
SUBMISSION:

SHEET: **P102**

PERMIT SET

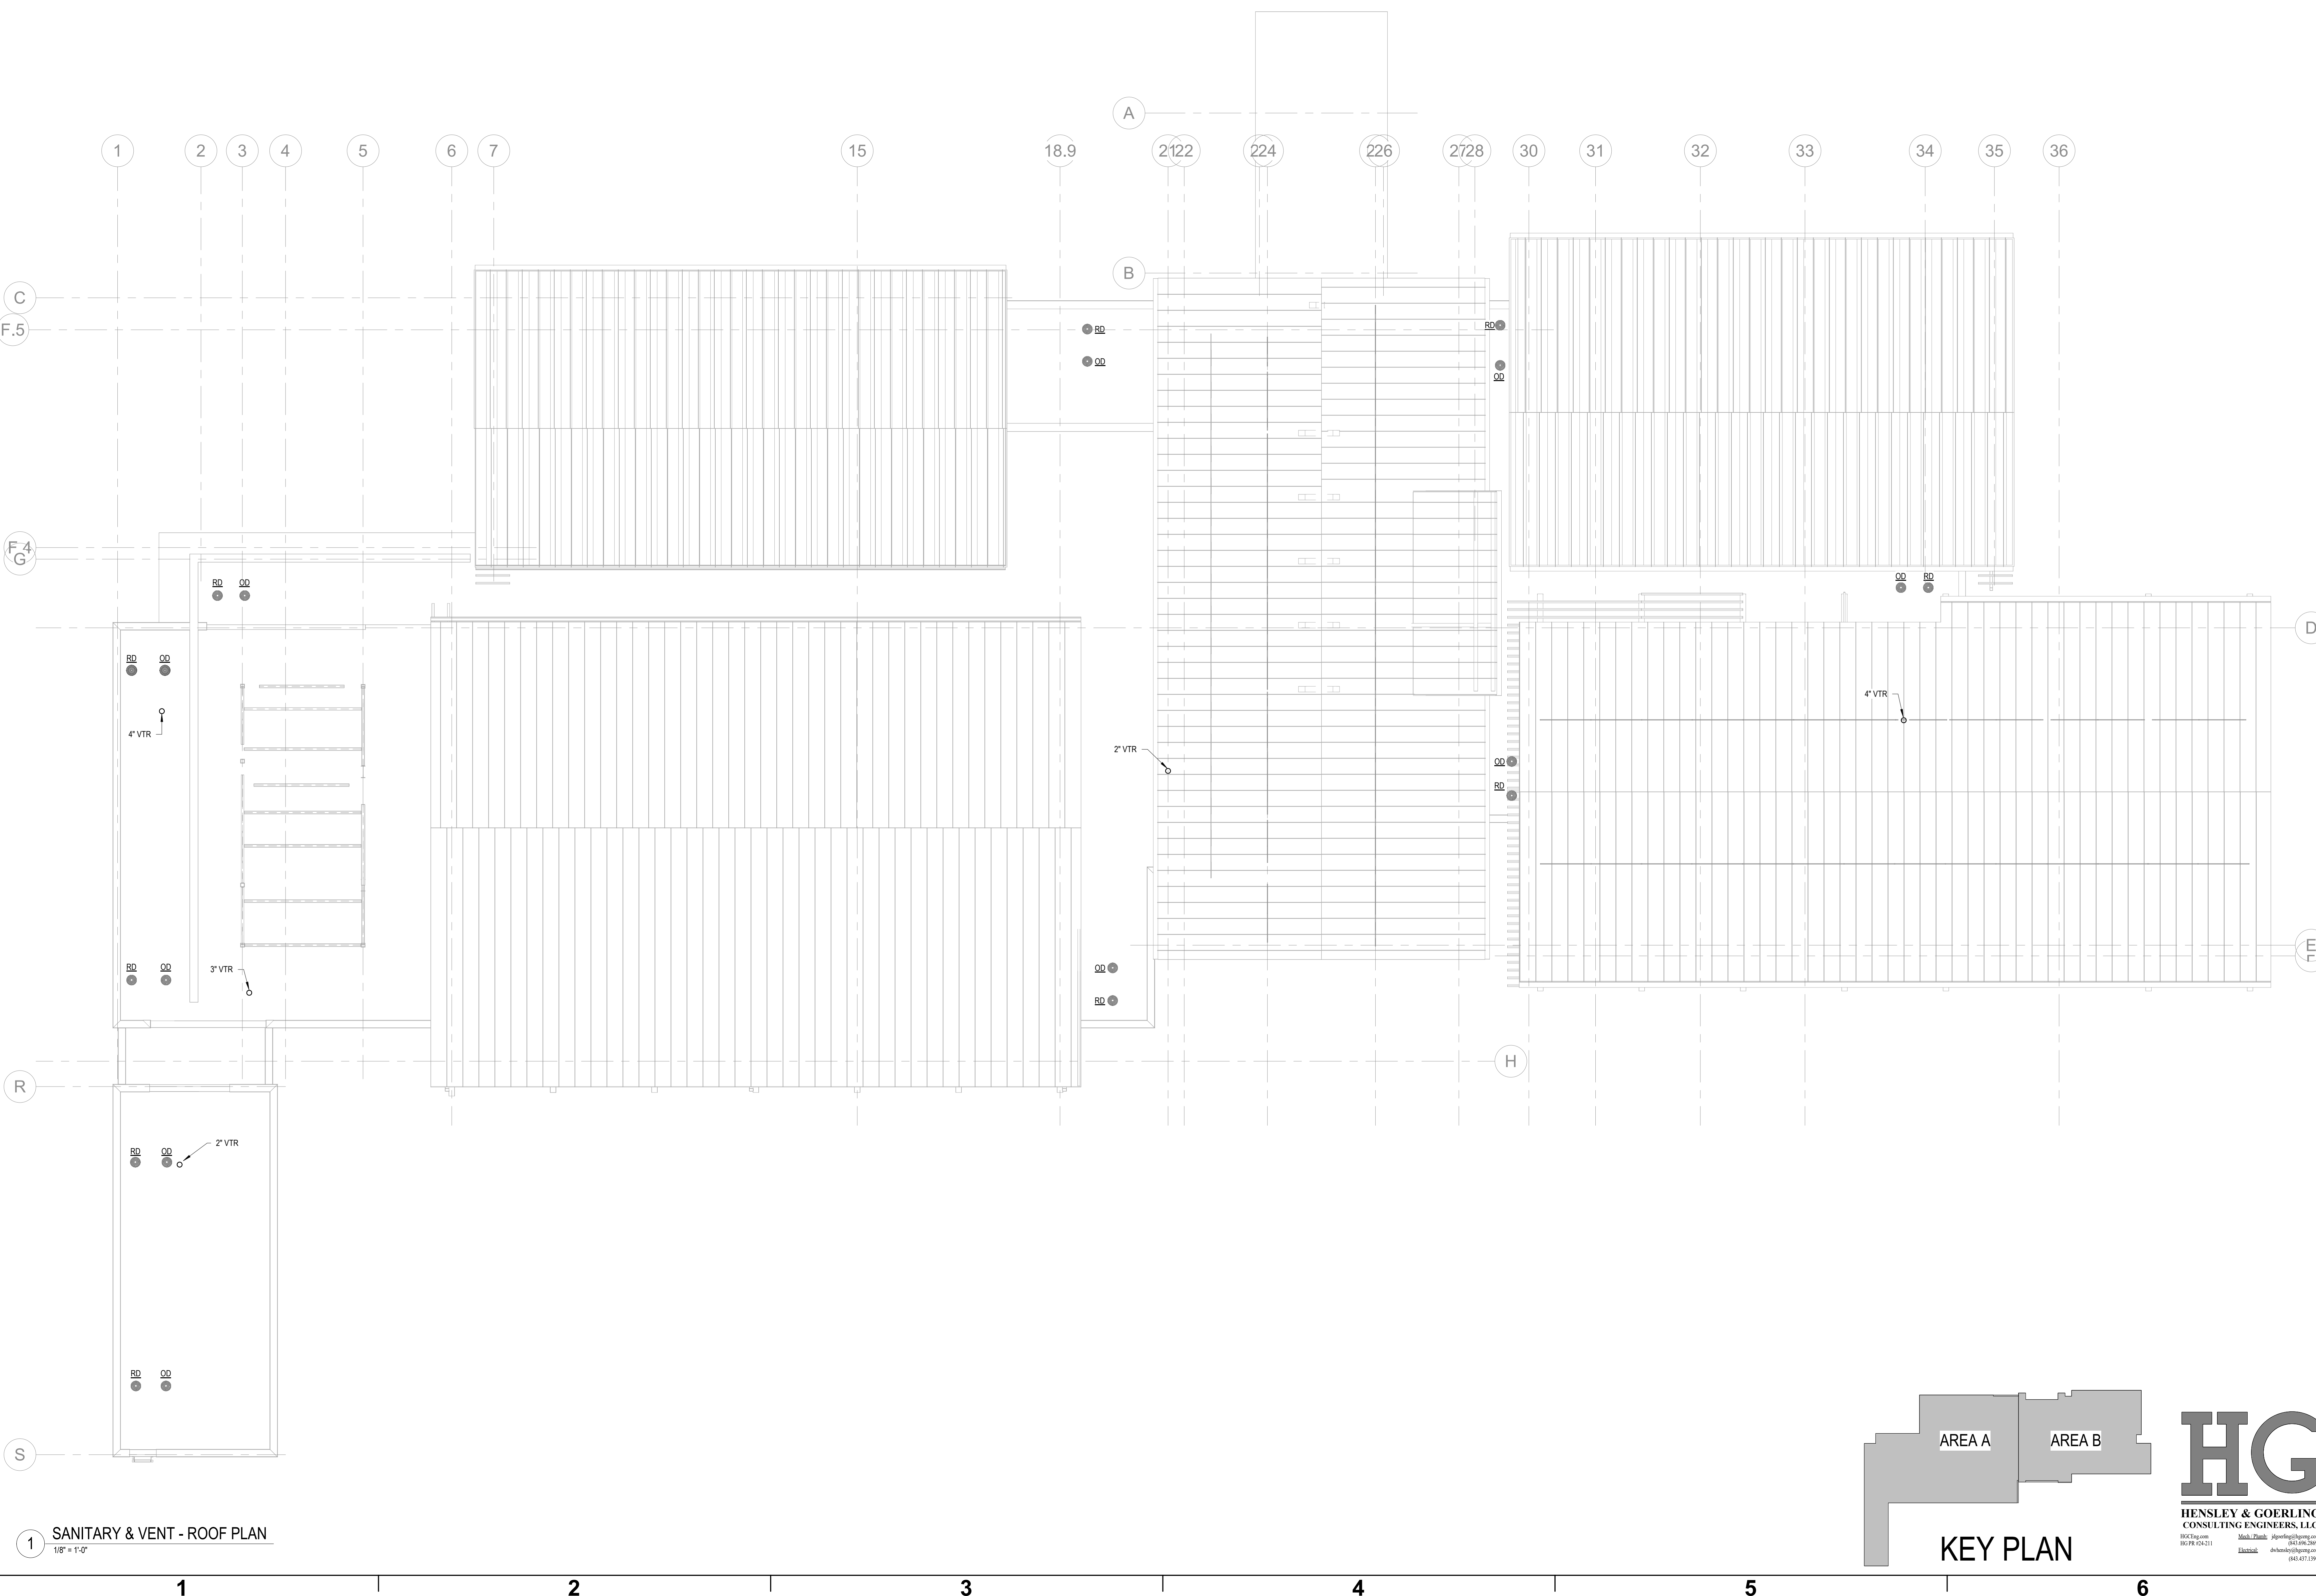

A





- DRAWING NOTES (H)

1. REFER TO OVERALL PLAN FOR PIPING CONTINUATION.
2. CONNECT DISHWASHER DRAIN TO P-4 SINK GARBAGE DISPOSAL. INSTALL PER MANUFACTURER'S GUIDELINES.
3. PROVIDE 2" VENT THROUGH ROOF FOR FLOOR SINK.



101 NORTH THIRD STREET, SUITE 500
WILMINGTON, NORTH CAROLINA 28401
TEL. 910.790.9901 FAX. 910.790.3111
WWW.LS3P.COM

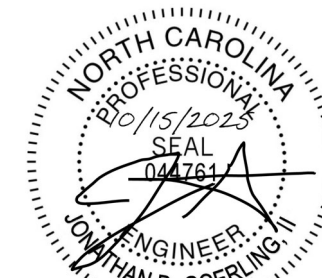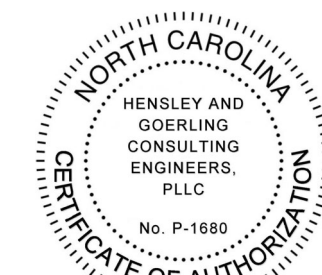

COPYRIGHT 2024 ALL RIGHTS RESERVED. PRINTED ON
ELECTRONIC DRAWINGS AND DOCUMENTATION MAY
NOT BE REPRODUCED IN ANY FORM WITHOUT WRITTEN
PERMISSION FROM LS3P ASSOCIATES LTD.

Pulte Del Webb Ocean Isle Beach Amenity Center

930 Ocean Isle Beach Road SW
Shallotte, NC 28470

LS3P PROJECT: 7154-231756

[illegible]


SHEET NAME:
PLUMBING -
ENLARGED PLANS

ORIG SUBMISSION: 2025.10.15

SHEET:

P301

PERMIT SET

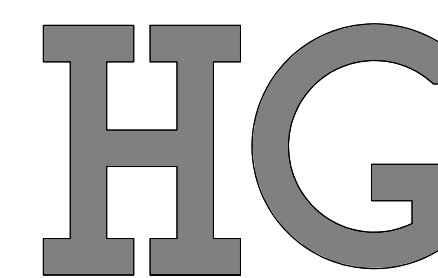


HENSLEY & GOERLING
CONSULTING ENGINEERS, LLC

HGCEng.com
HG PR #24-211


Mech / Plumb jgoerling@hgceng.com
(843) 696-2840

Electrical dhensley@hgceng.com
(843) 437-1313


10/15/2025 12:15:43 PM

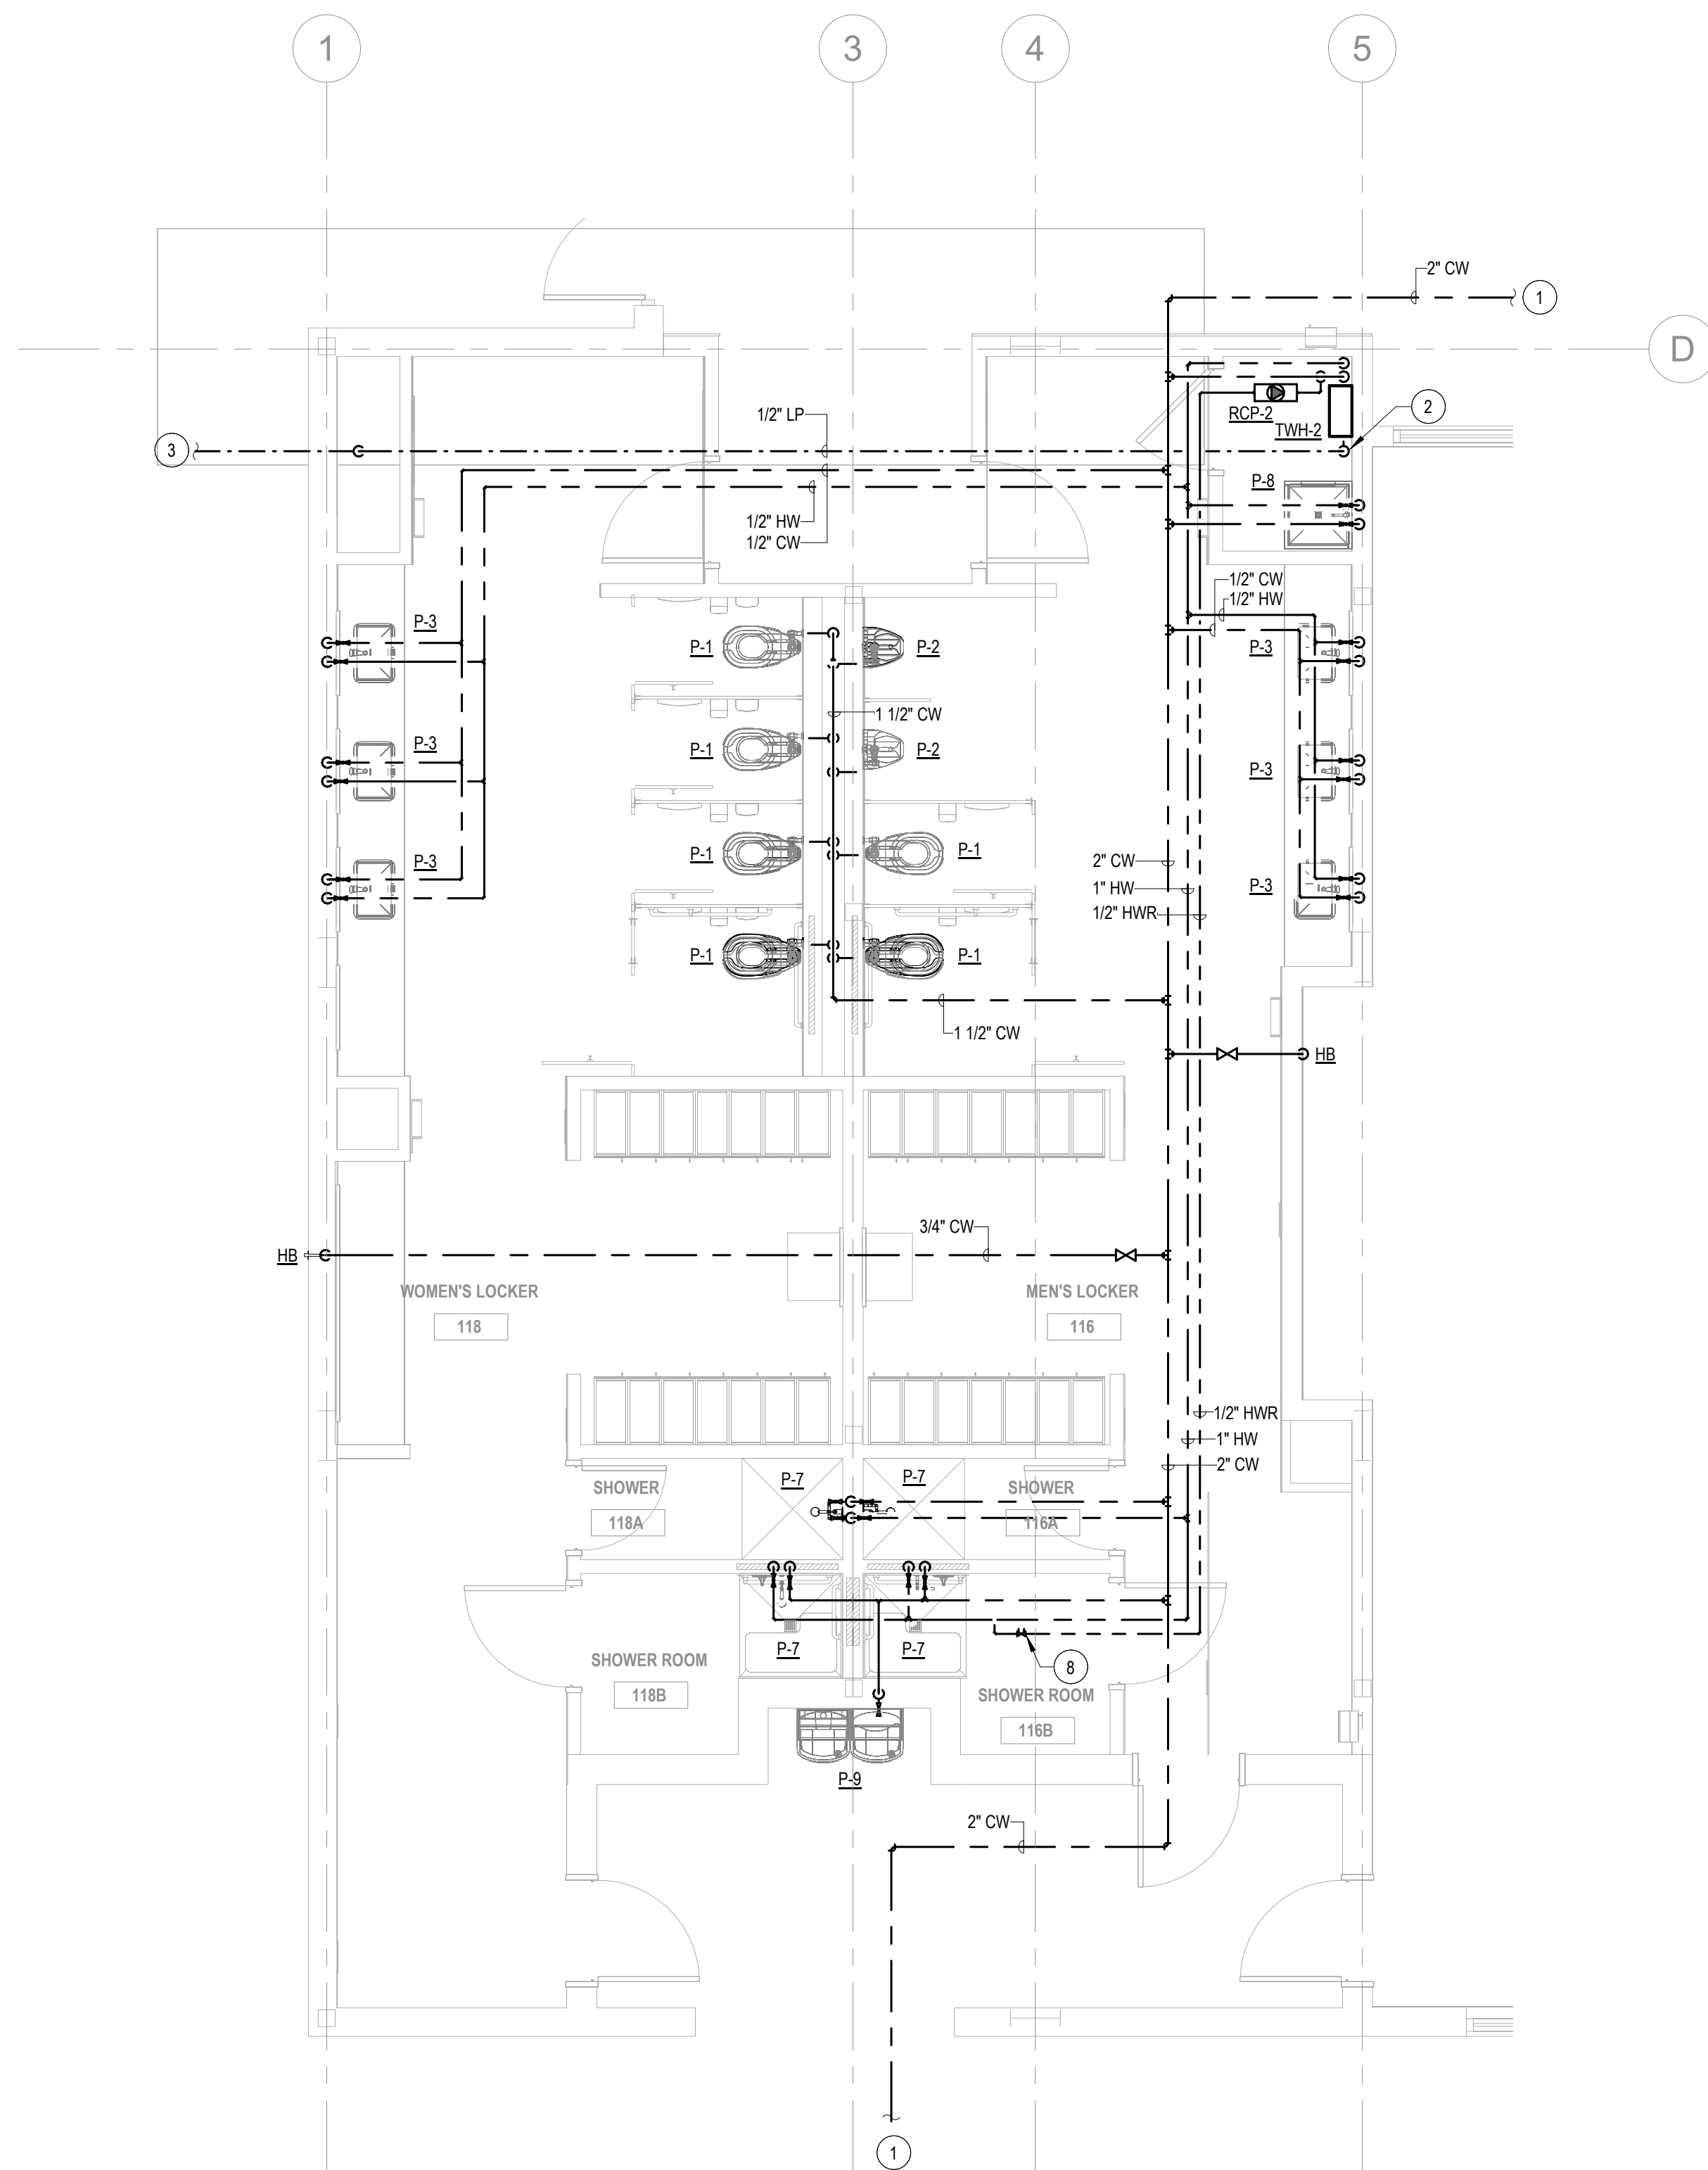


1 DOMESTIC WATER AND GAS - ELNARGED PLAN - LOCKER ROOMS
1/4" = 1'-0"

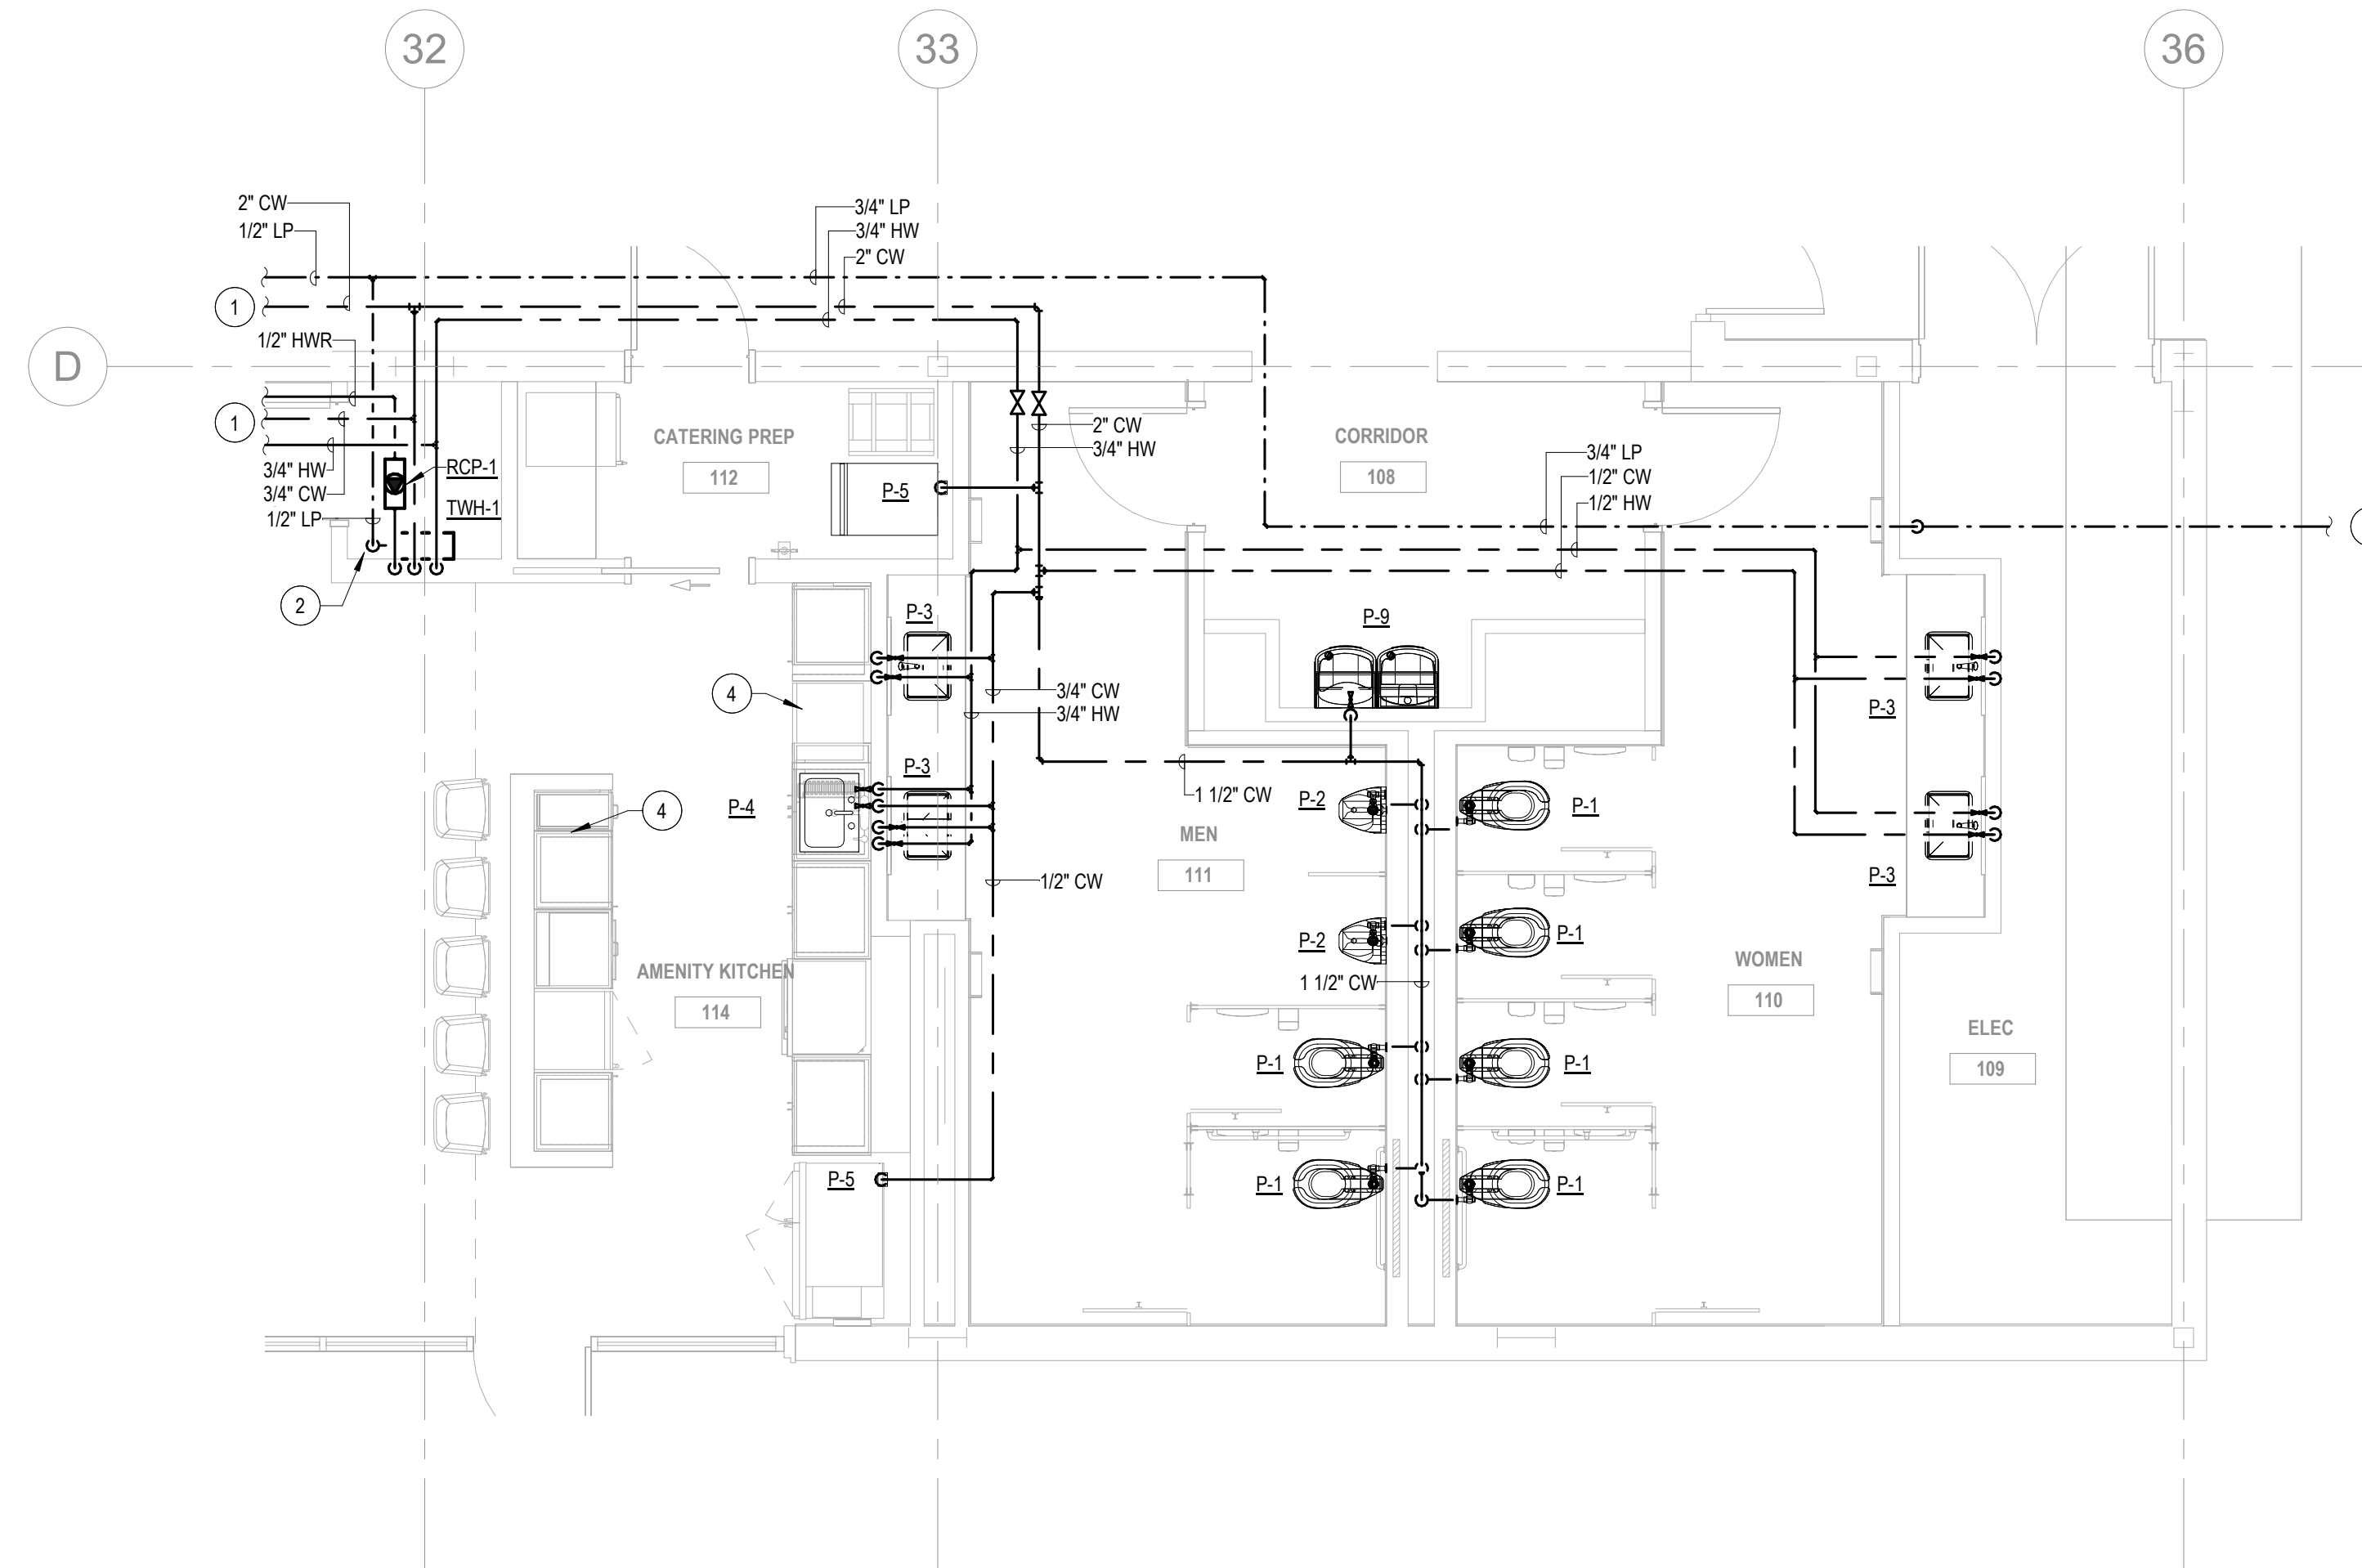


2 DOMESTIC WATER AND GAS - ENLARGED PLAN - RESTROOMS
1/4" = 1'-0"

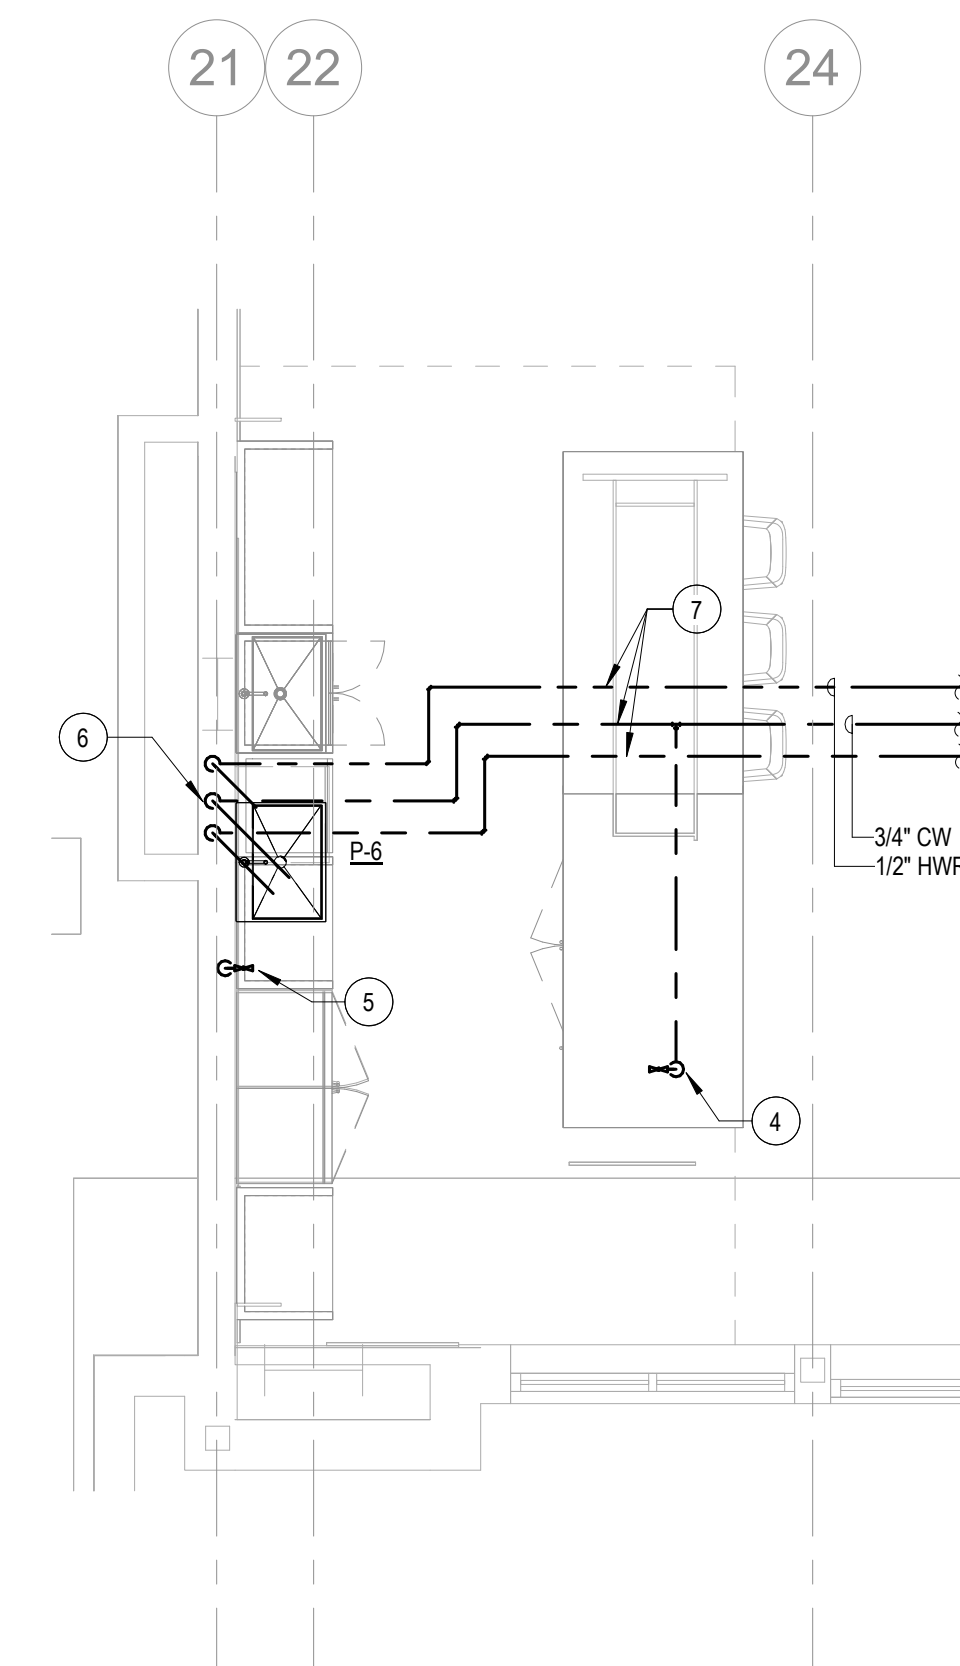

3 DOMESTIC WATER AND GAS - ENLARGED PLAN - BAR
1/4" = 1'-0"

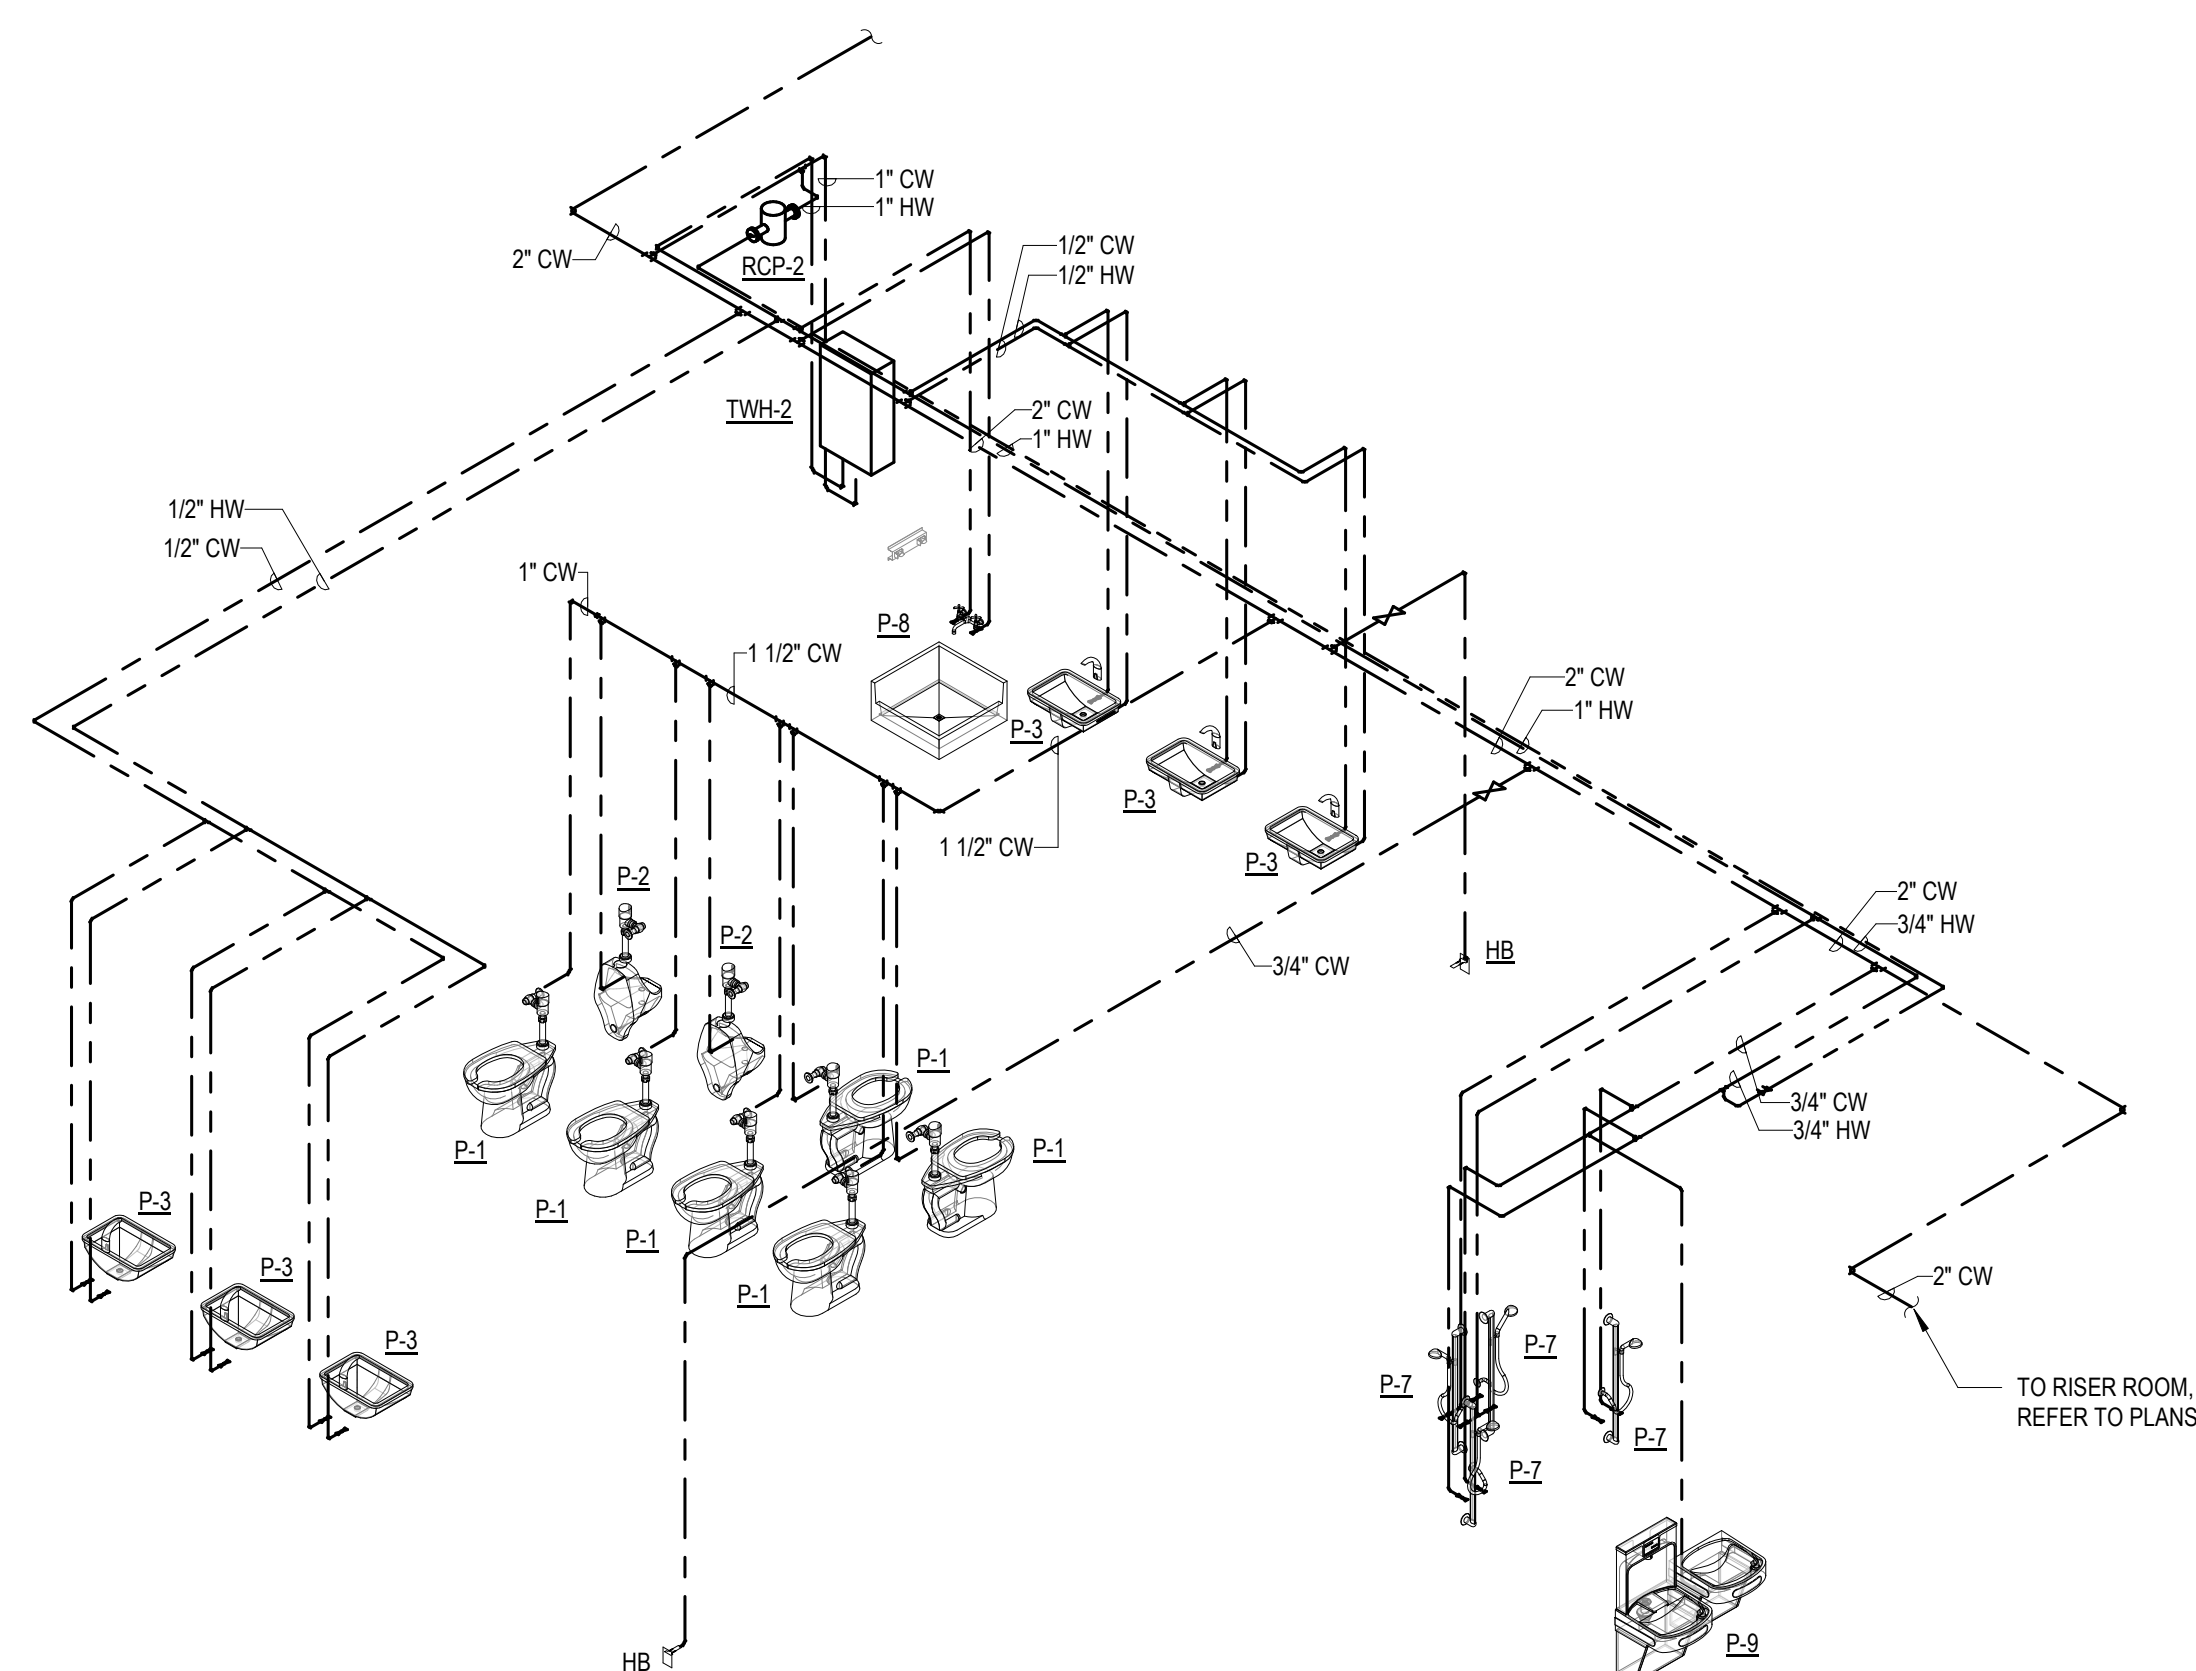

4 DOMESTIC WATER ISOMETRIC - LOCKER ROOMS

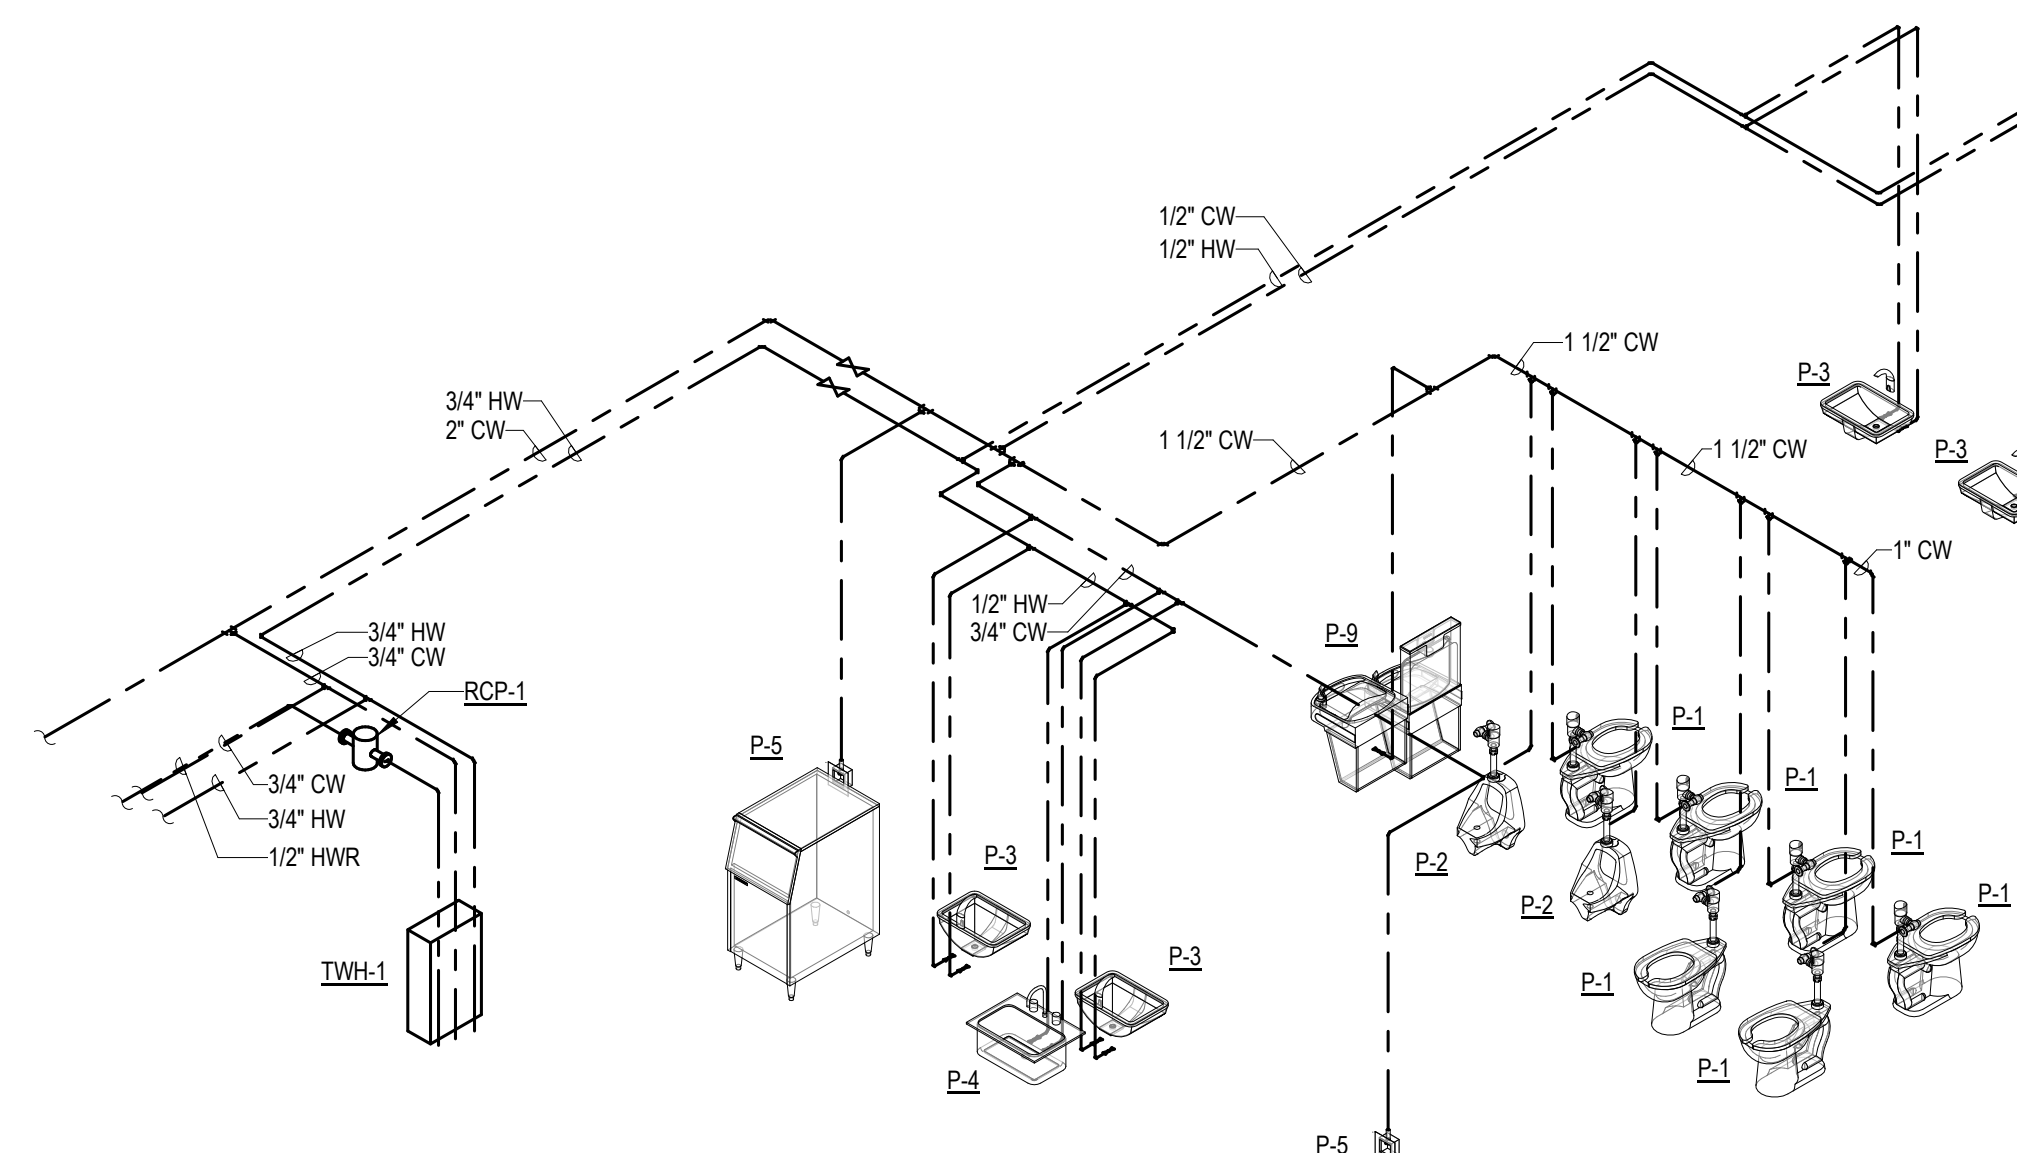

5 DOMESTIC ISOMETRIC - RESTROOMS

GENERAL DRAWING NOTES

- A. ANY PIPE INVERT ELEVATIONS PROVIDED ON THE PLANS ARE FOR REFERENCE ONLY.
- B. REFER TO PLUMBING FIXTURE SCHEDULE FOR FIXTURE DOMESTIC WATER, SANITARY AND VENT PIPING CONNECTION SIZES.
- C. REFER TO FOOD SERVICE PLANS FOR ADDITIONAL INFORMATION ON REQUIRED WATER CONNECTIONS TO FOOD SERVICE EQUIPMENT.

DRAWING NOTES ⓘ

1. REFER TO OVERALL PLAN FOR PIPING CONTINUATION.
2. 1/2" PROPANE PIPING DOWN TO TWH.
3. 3/4" PROPANE PIPING, ROUTE UNDERGROUND TO STORAGE TANK. COORDINATE WITH CIVIL SITE PLANS PRIOR TO INSTALLATION. PROVIDE WATER TIGHT PIPE. SEE 1/2" INSULATION DETAIL.
4. PROVIDE 1/2" HW CONNECTION TO DISHWASHER FROM SINK HW LINE. INSTALL PER MANUFACTURER'S CONNECTIONS.
5. PROVIDE 1/2" HW CONNECTION FOR DISH WASHER. REFER TO KITCHEN EQUIPMENT PLANS.
6. 3/4" CW, 3/4" HW AND 1/2" HWR UP FROM BELOW SLAB. ROUTE CW AND 1/2" HWR TO SERVE BAR FIXTURES. THE HWR PIPING TO HW PIPING AND PROVIDE A CIRCUIT SETTER BALANCING VALVE SET TO 2.0 GPM.
7. CW, HW AND HWR PIPING ROUTED UNDER SLAB AND UP TO SERVE BAR FIXTURES.
8. PROVIDE CIRCUIT SETTER BALANCING VALVE. SET TO 2.0 GPM.



101 NORTH THIRD STREET, SUITE 500
WILMINGTON, NORTH CAROLINA 28401
TEL. 910.790.9901 FAX. 910.790.3111
WWW.LS3P.COM



COPYRIGHT 2024 ALL RIGHTS RESERVED. PRINTED OR
ELECTRONIC DRAWINGS AND DOCUMENTATION MAY
NOT BE REPRODUCED IN ANY FORM WITHOUT WRITTEN
PERMISSION FROM LS3P ASSOCIATES LTD.

Pulte Del Webb Ocean Isle Beach Amenity Center

9930 Ocean Isle Beach Road SW
Shallotte, NC 28470

IS3P PROJECT: 7154-231756

[illegible]


SHEET NAME:
PLUMBING -
ENLARGED PLANS

ORIG 2025.10.15
SUBMISSION:

SHEET:

P302

PERMIT SET

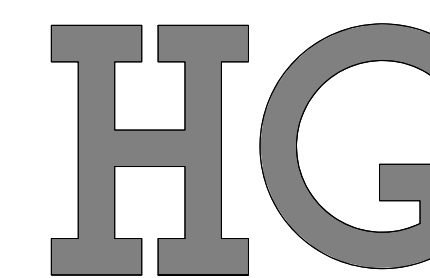

HENSLEY & GOERLING
CONSULTING ENGINEERS, LLC

HOC/Eng.com Media / Plans: jdggoerling@hgeng.com
HG PR #24-211 (843) 696-2869

Electrical: dw.hensley@hgeng.com
 (843) 437-1166

